


# FOR TENDER PURPOSE ONLY

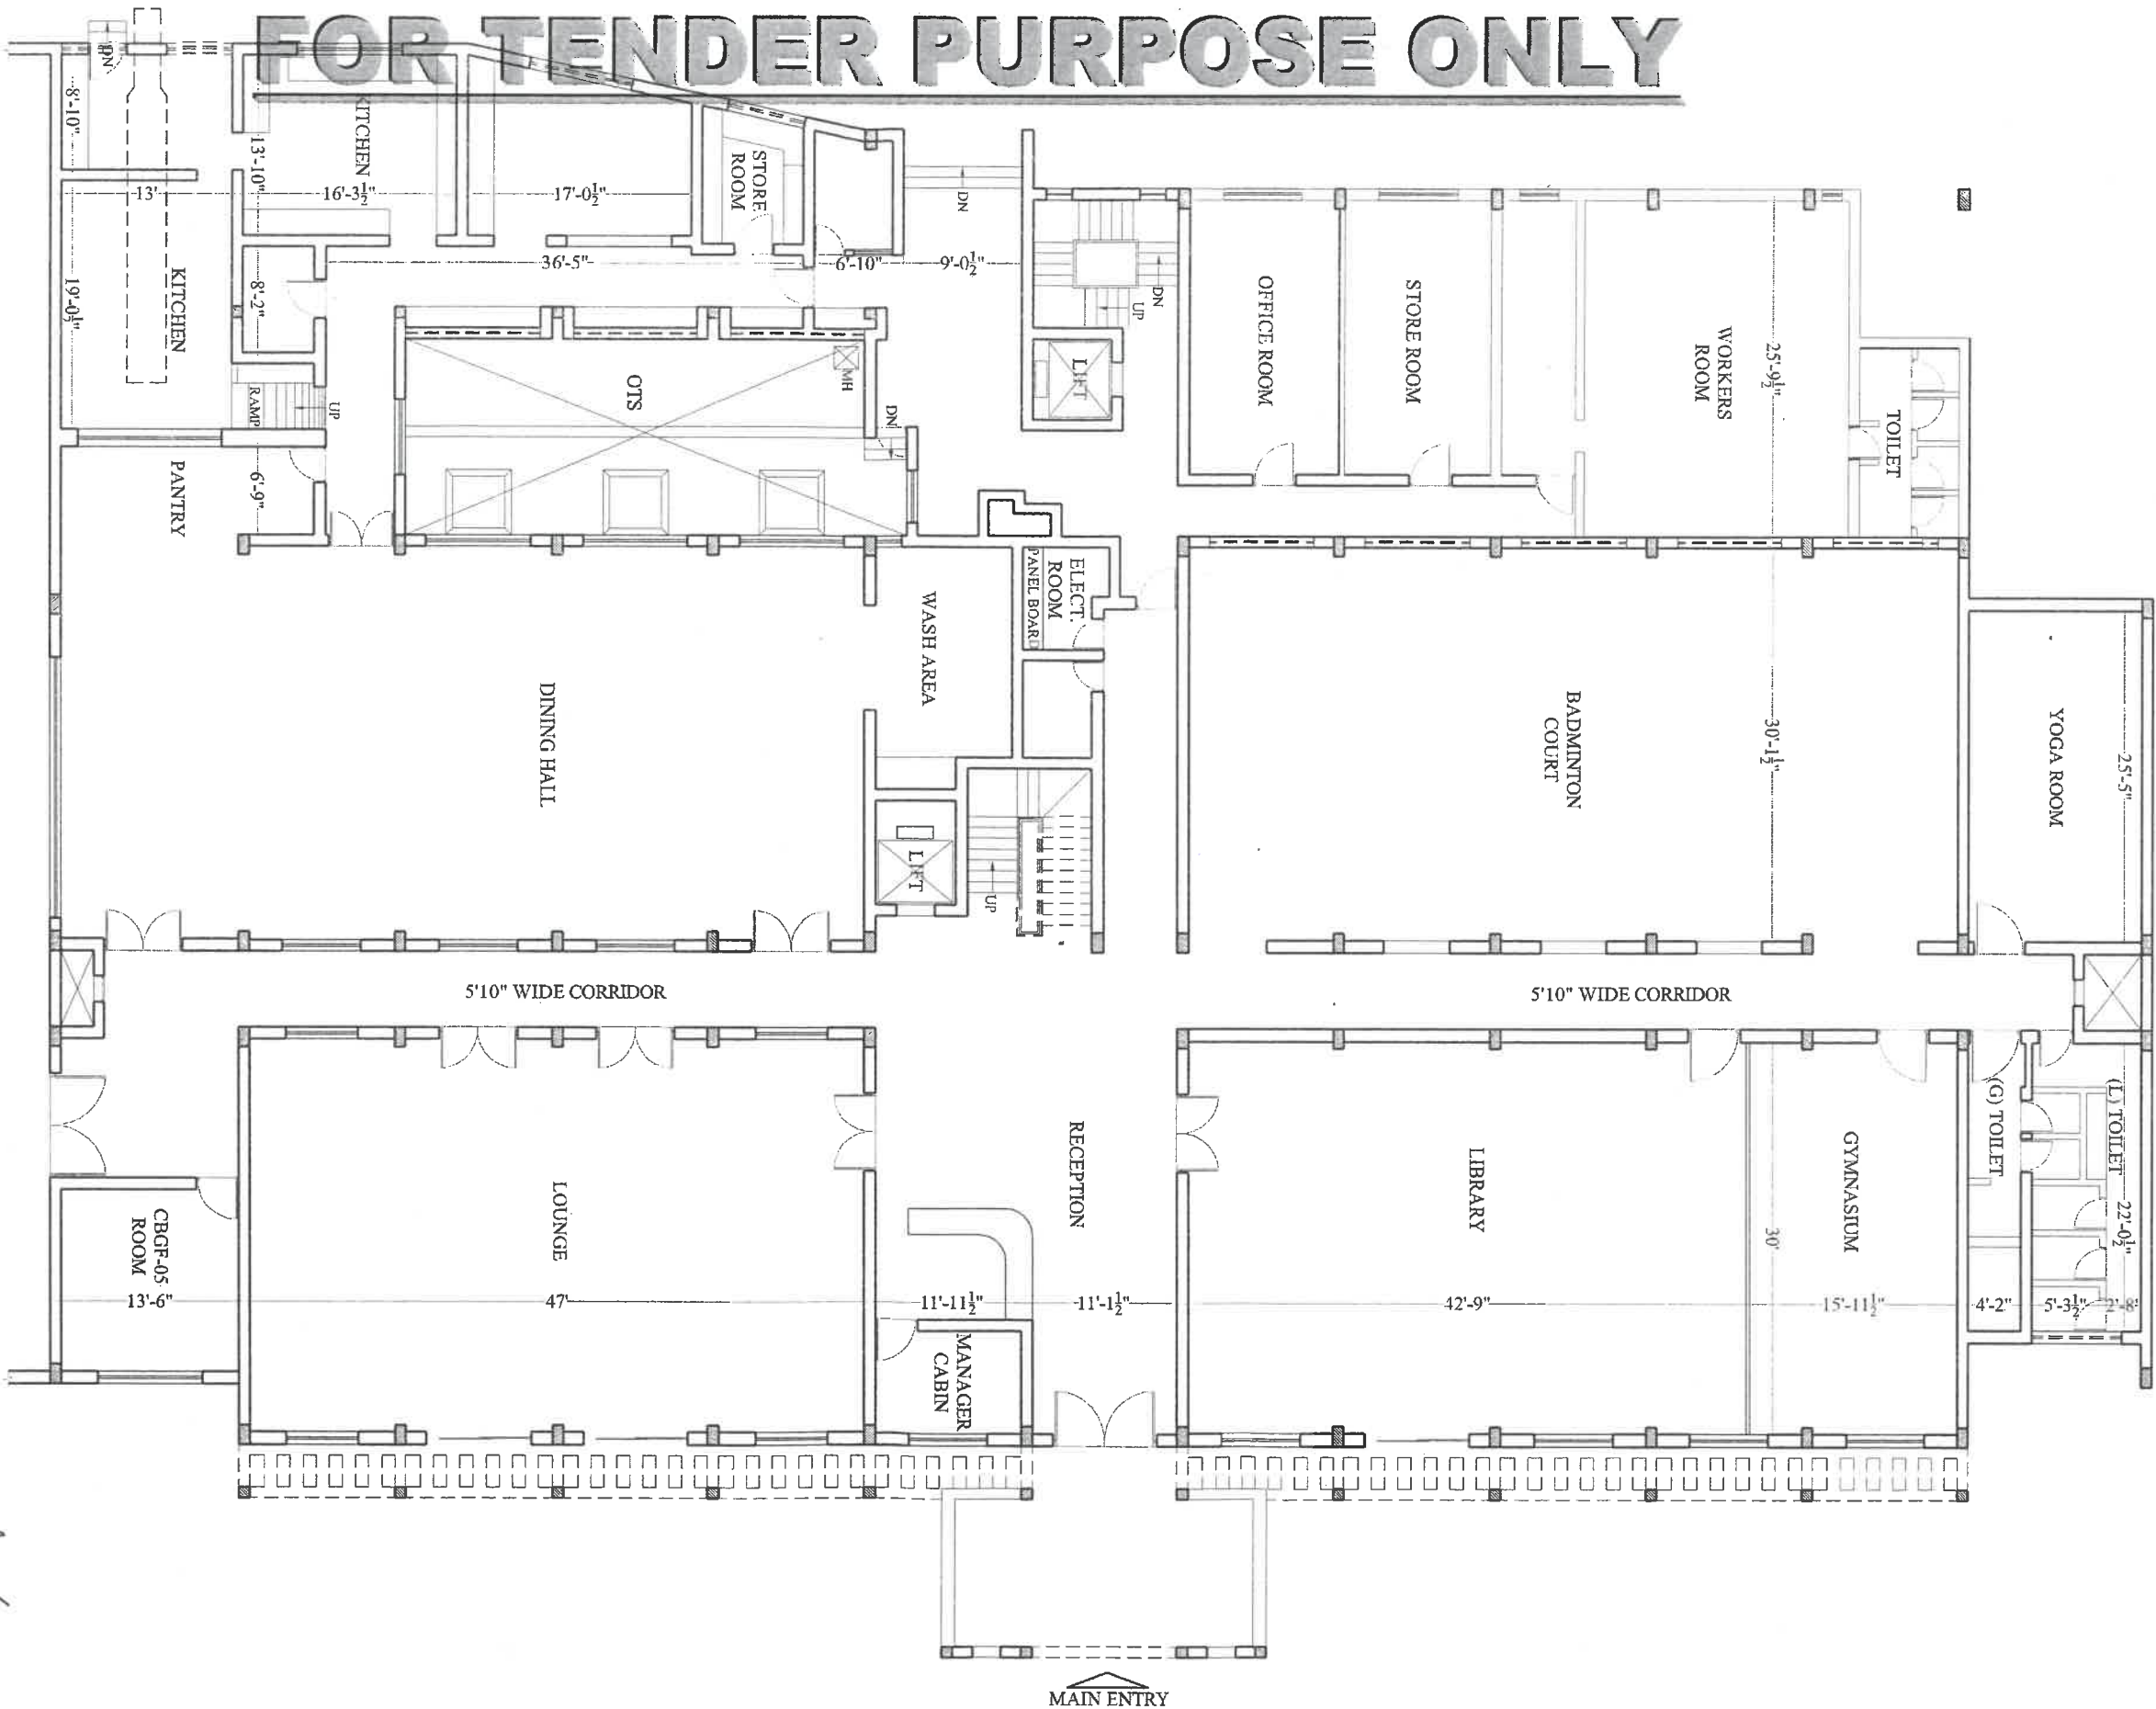

NOTE:  
THIS DRAWING OR DESIGN IS COPYRIGHT. IT IS THE PROPERTY OF THE ARCHITECTS OR DESIGNERS AND IS NOT TO BE REPRODUCED, COPIED OR HANDED OVER TO A THIRD PARTY OR USED FOR ANY PURPOSE OTHER THAN THAT FOR WHICH IT HAS BEEN ACTUALLY LOANED. READ THE DRAWING. DO NOT MEASURE IT. INFORM THE ARCHITECTS OR DESIGNERS OF ANY DISCREPANCIES IN THE DRAWING IMMEDIATELY.

PROJECT NAME:  
**HOSTEL( RENOVATION )**  
CLIENT NAME:  
**INDIAN BANK**  
PLACE OF THE PROJECT:  
**CHENNAI.**


TITLE:-  
**EXISTING**  
**GROUND FLOOR PLAN**  
SCALE : 1"=126"190"144"  
DATE : 21-08-2021  
DRN BY: **EUGINE**  
DRG NO: **DRAWING-01**  
JOB NO:  
CHK BY: **R.KANNAN**

**FOARCONS**  
FORUM ARCHITECTURAL CONSULTANTS  
NO#16 ANGAL FLATS, 3/2# NAKKIRAN ST,  
WEST MAMBALAM, CHENNAI - 600 033.  
PH: 044 24812179, CELL-9381034445.  
EMAIL ID: FOARCONS@YMAIL.COM



*R. Kannan*

# FOR TENDER PURPOSE ONLY

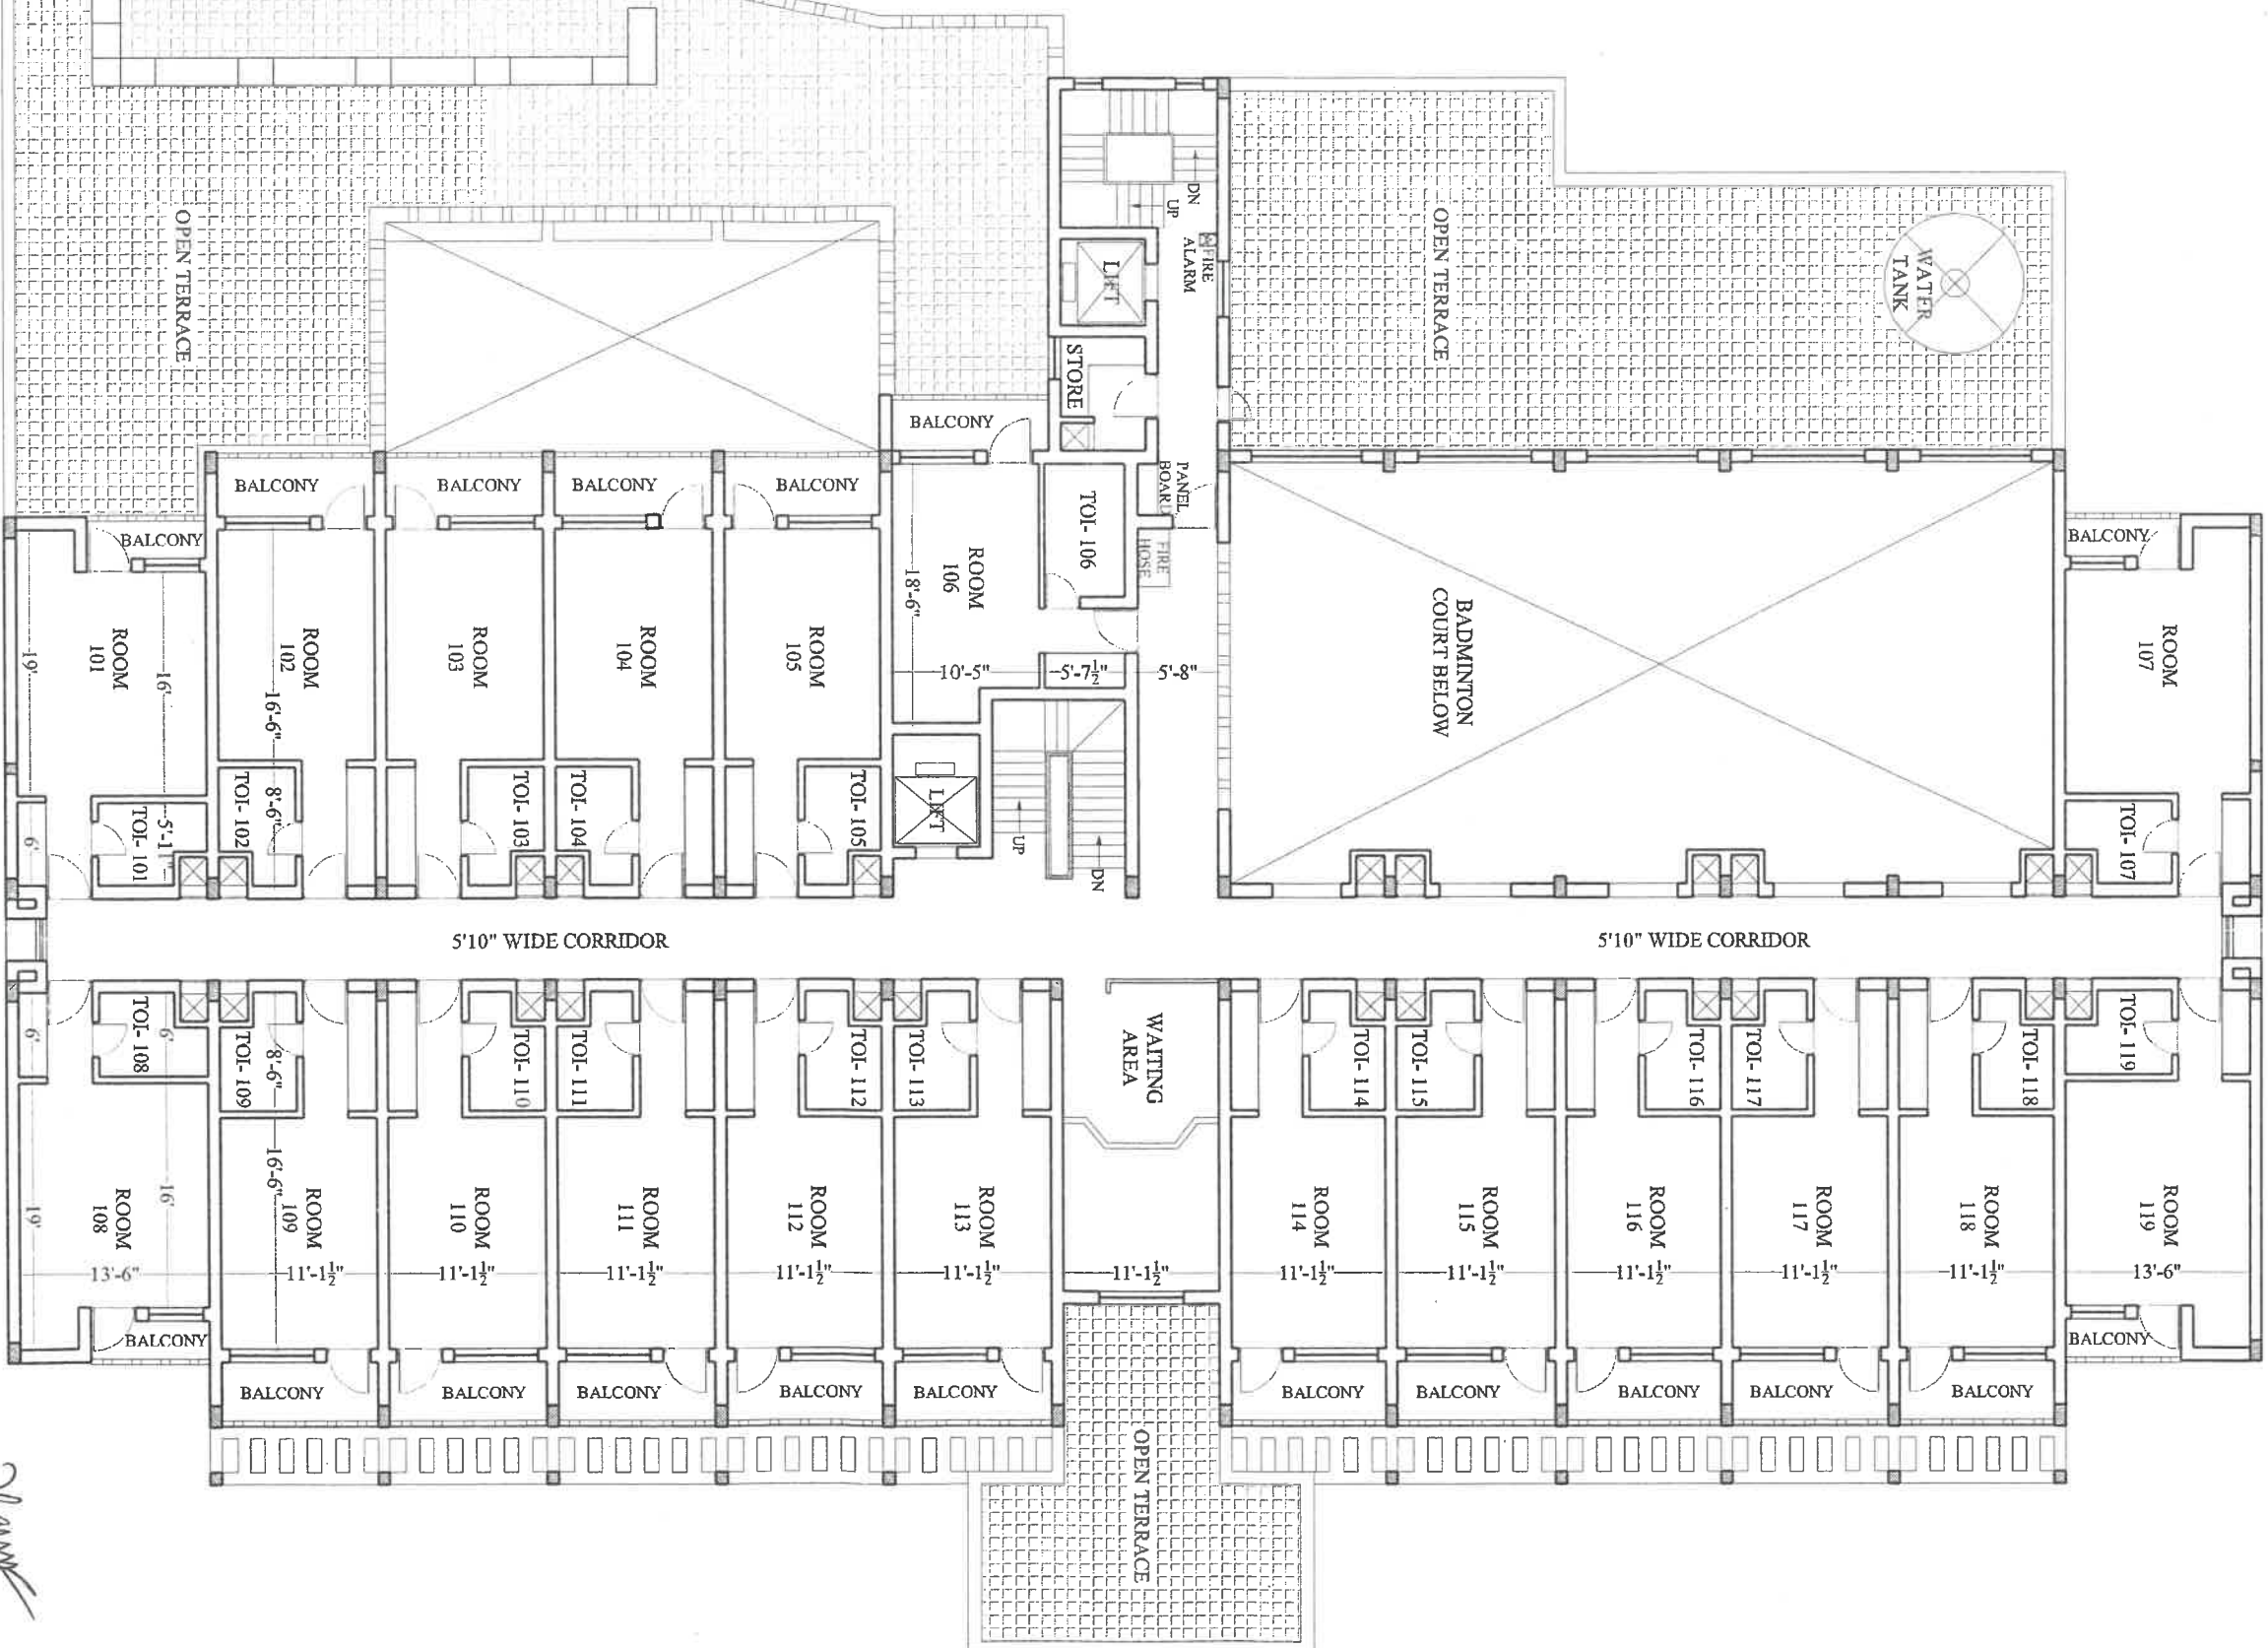

NOTE:  
THIS DRAWING OR DESIGN IS COPYRIGHT. IT IS THE PROPERTY OF THE ARCHITECTS OR DESIGNERS AND IS NOT TO BE REPRODUCED, COPIED, OR HANDED OVER TO A THIRD PARTY OR USED FOR ANY PURPOSE OTHER THAN THAT FOR WHICH IT HAS BEEN ACTUALLY LOANED. READ THE DRAWING, DO NOT MEASURE IT. INFORM THE ARCHITECTS OR DESIGNERS OF ANY DISCREPANCIES IN THE DRAWING IMMEDIATELY.

PROJECT NAME:  
**HOSTEL ( RENOVATION )**  
CLIENT NAME:  
**INDIAN BANK**  
PLACE OF THE PROJECT:  
**CHENNAI.**

TITLE:-  
**EXISTING**  
**FIRST FLOOR PLAN**

SCALE : 1"=12'6" (190'4")  
DATE : 21-08-2021  
DRN BY: EUGINE  
DRG NO: DRAWING-02  
JOB NO:  
CHK BY: R.KANNAN


**FOARCONS**  
FORUM ARCHITECTURAL CONSULTANTS  
NO#16 GANGA FLATS, 3/2# NAKKIRAN ST.,  
WEST MAMBALAM, CHENNAI - 600 053.  
PH: 044 24812179, CELL-9381034445,  
EMAIL ID: FOARCONS@YMAIL.COM



*R. Kannan*



# FOR TENDER PURPOSE ONLY

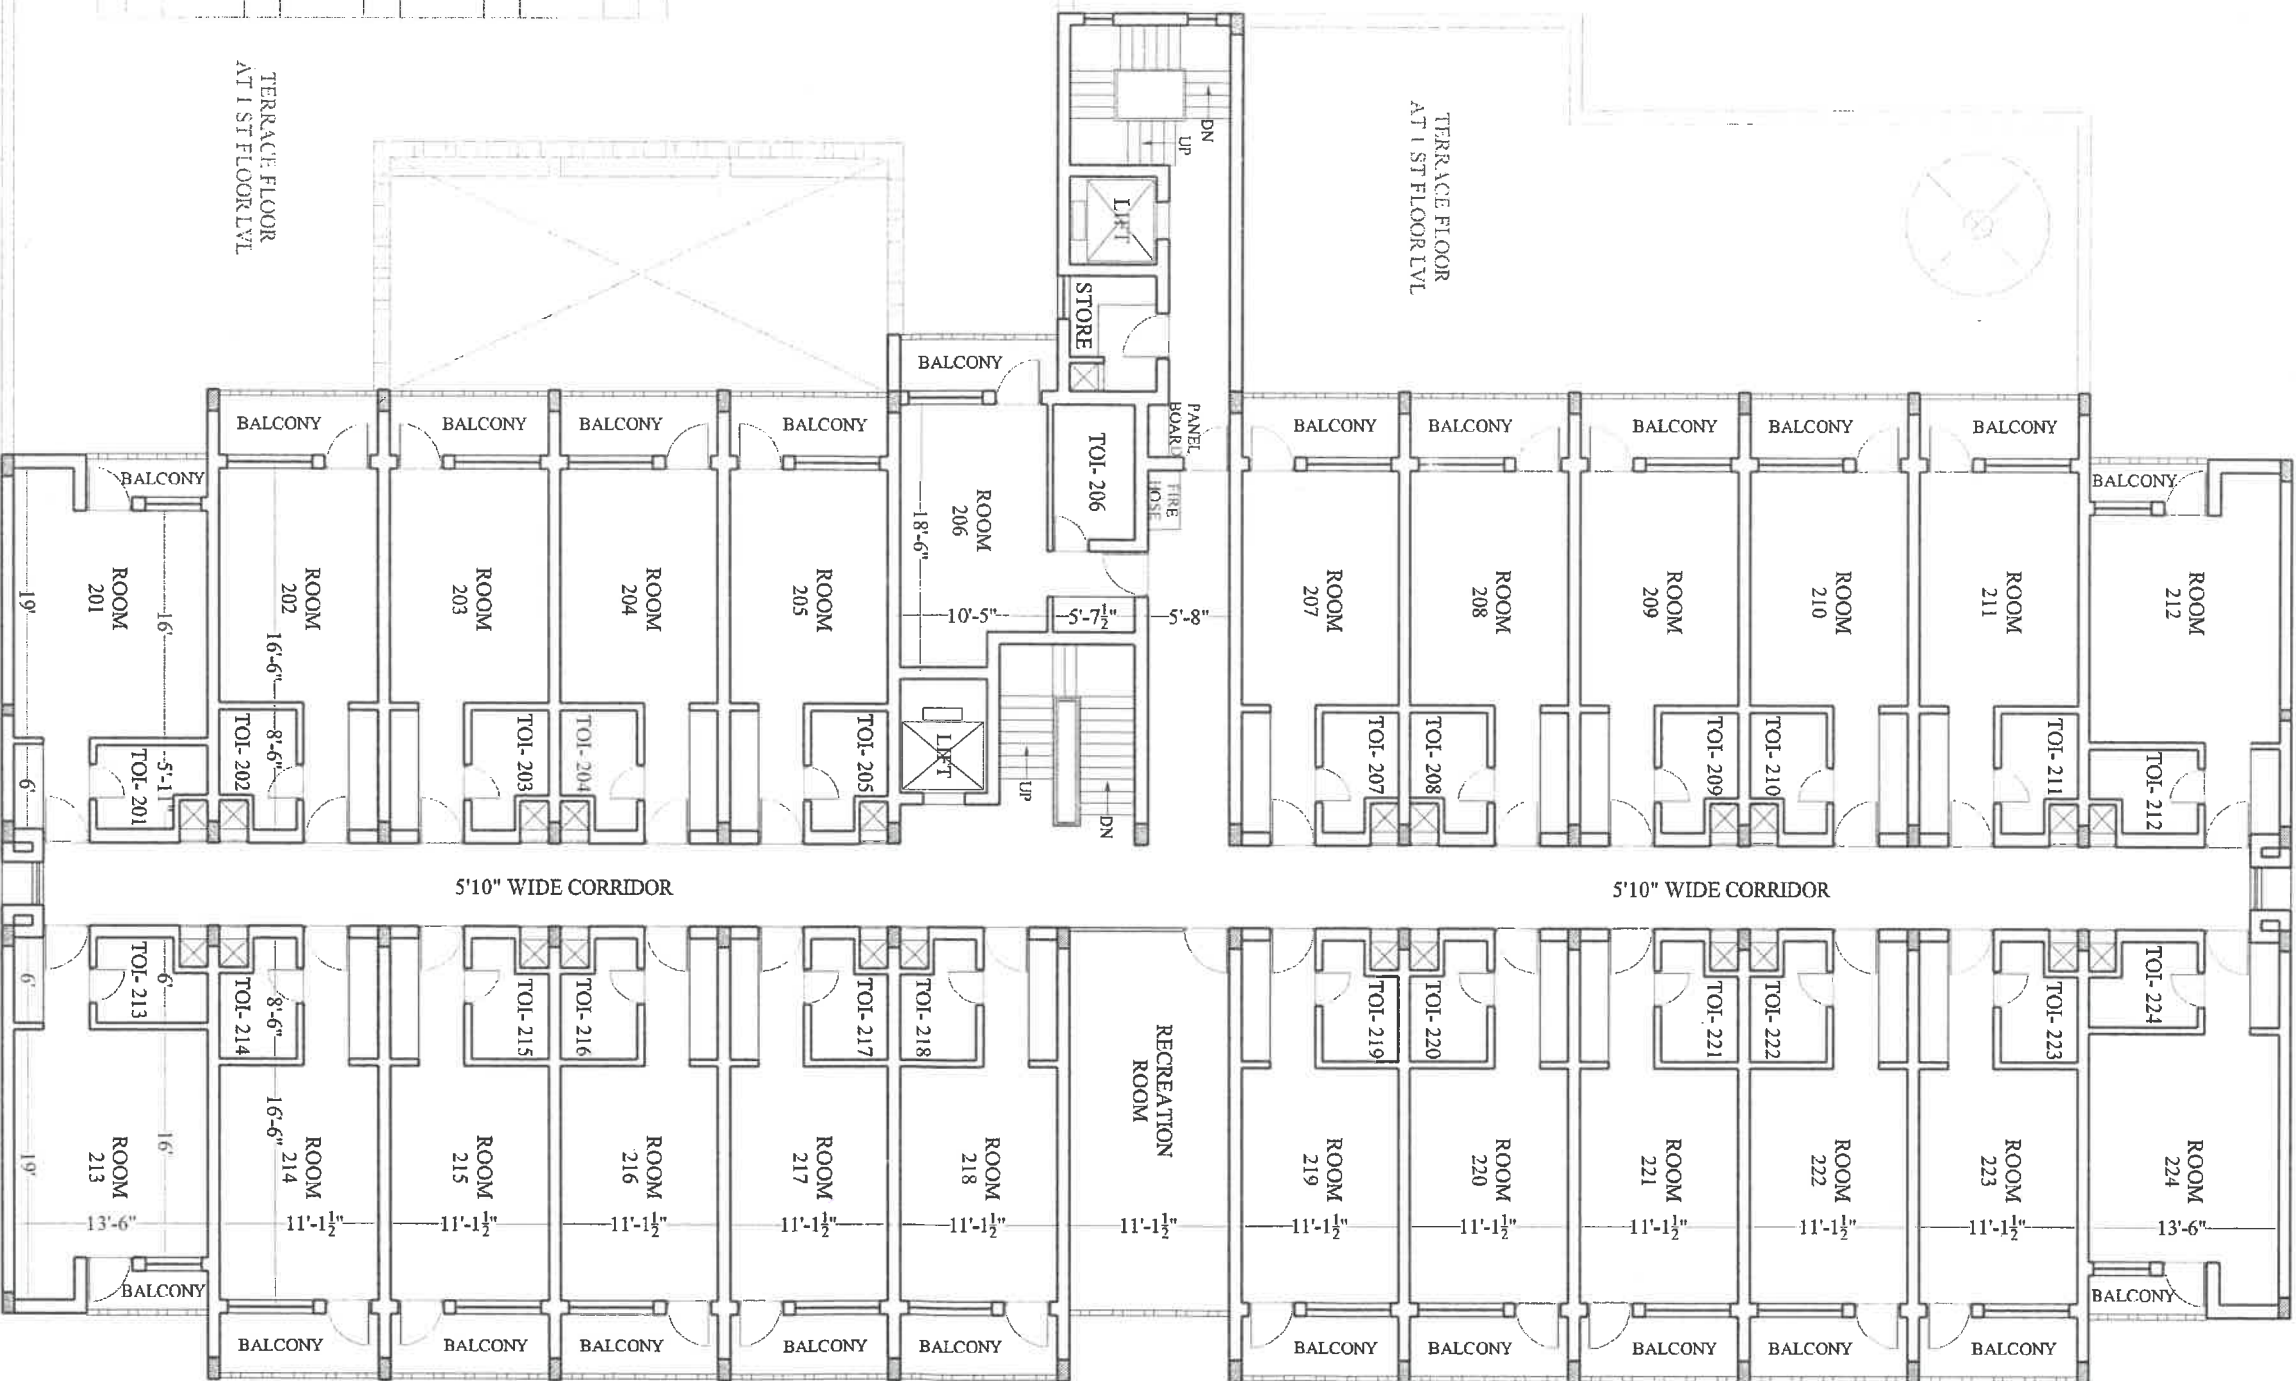

*R. Kannan*

NOTE: THIS DRAWING OR DESIGN IS COPYRIGHT. IT IS THE PROPERTY OF THE ARCHITECTS OR DESIGNERS AND IS NOT TO BE REPRODUCED, COPIED OR HANDED OVER TO A THIRD PARTY OR USED FOR ANY PURPOSE OTHER THAN THAT FOR WHICH IT HAS BEEN ACTUALLY LOANED. READ THE DRAWING, DO NOT MEASURE IT. INFORM THE ARCHITECTS OR DESIGNERS OF ANY DISCREPANCIES IN THE DRAWING IMMEDIATELY.


PROJECT NAME:  
**HOSTEL( RENOVATION )**  
CLIENT NAME:  
**INDIAN BANK**  
PLACE OF THE PROJECT:  
**CHENNAI.**

TITLE:-  
**EXISTING**  
**2nd & 3rd**  
**FLOOR PLAN**

SCALE : 1"=12'6"/19'0" (A)  
DATE : 21-08-2021  
DRN BY: **EUGINE**  
DRG NO: **DRAWING-03**  
JOB NO:  
CHK BY: **R.KANNAN**

**FOARCONS**  
FORUM ARCHITECTURAL CONSULTANTS  
NO#16 GANGA FLATS, 3/2# NAKKIRAN ST.,  
WEST MAMBALAM, CHENNAI - 600 035.  
PH: 044 24812179, CELL-9381034445.  
EMAIL ID: FOARCONS@YMAIL.COM

# FOR TENDER PURPOSE ONLY

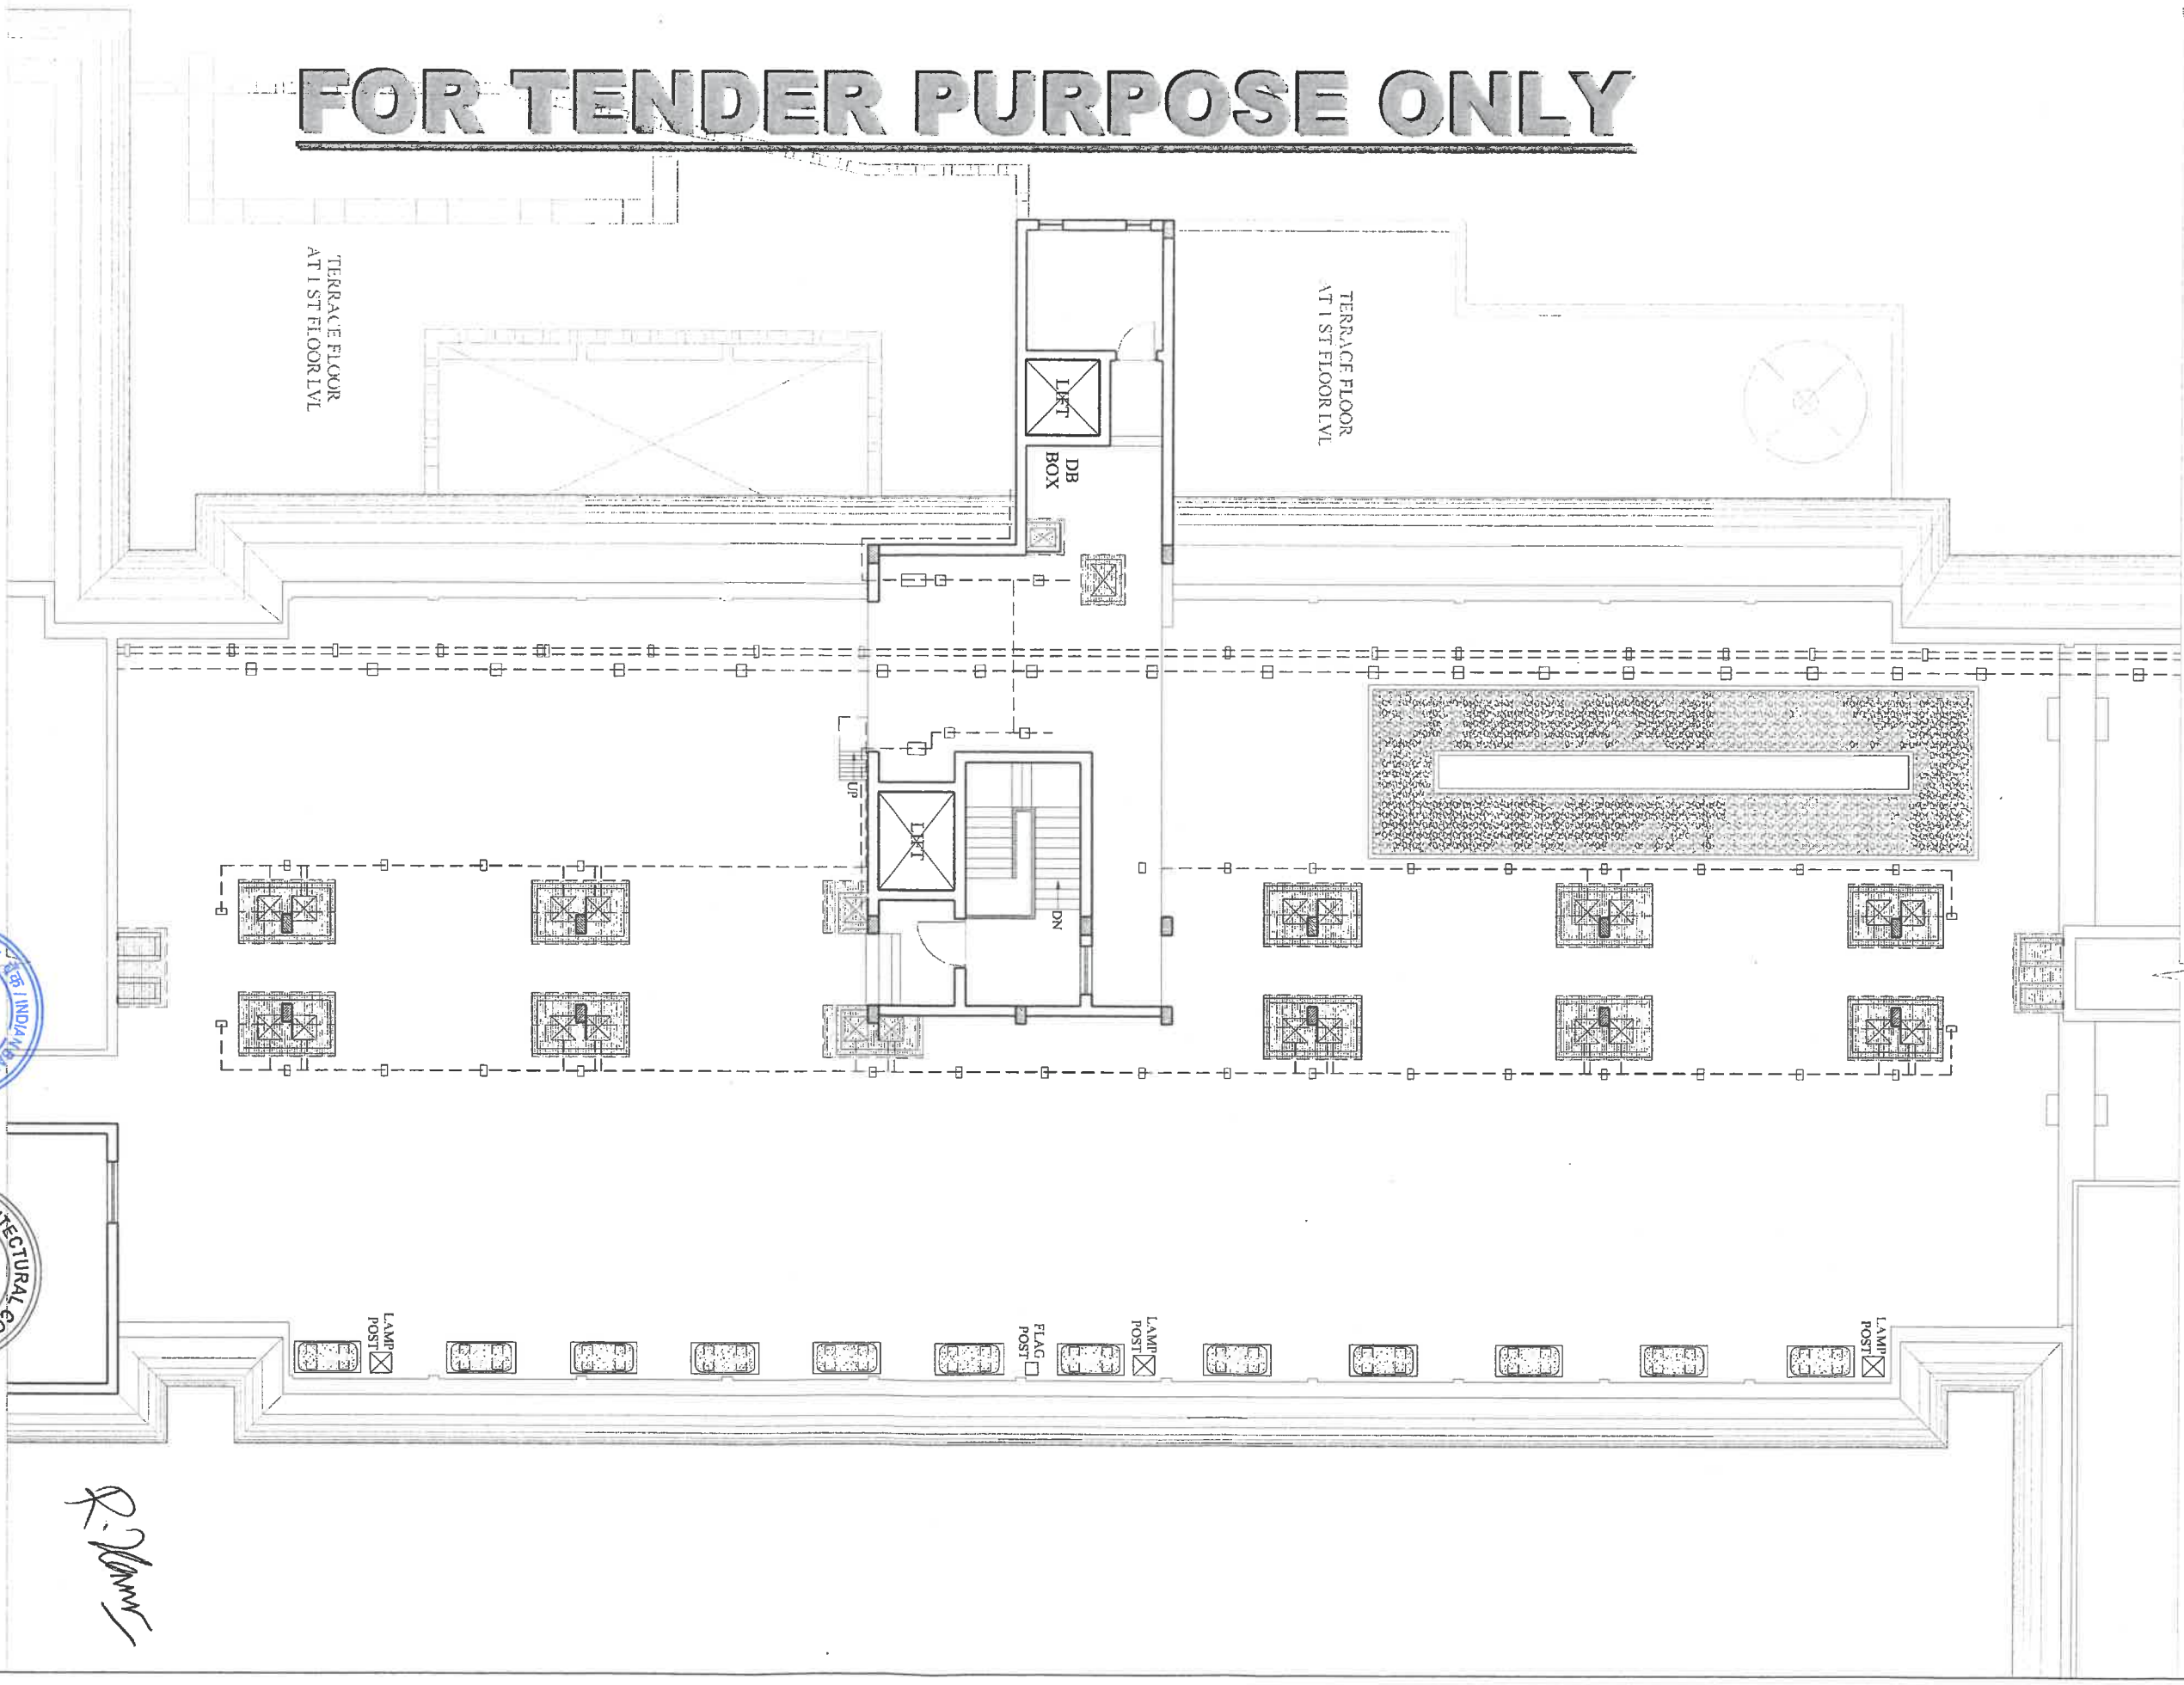

NOTE:  
THIS DRAWING OR DESIGN IS COPYRIGHT. IT IS THE PROPERTY OF THE ARCHITECTS OR DESIGNERS AND IS NOT TO BE REPRODUCED, COPIED, OR HANDED OVER TO A THIRD PARTY OR USED FOR ANY PURPOSE OTHER THAN THAT FOR WHICH IT HAS BEEN ACTUALLY LOANED. READ THE DRAWING, DO NOT MEASURE IT. INFORM THE ARCHITECTS OR DESIGNERS OF ANY DISCREPANCIES IN THE DRAWING IMMEDIATELY.

PROJECT NAME:  
**HOSTEL( RENOVATION )**  
CLIENT NAME:  
**INDIAN BANK**  
PLACE OF THE PROJECT:  
**CHENNAI.**

TITLE:-  
**EXISTING  
TERRACE  
FLOOR PLAN**


SCALE : 1"=12'6"19'0"(A4)  
DATE : 21-08-2021  
DRN BY: EUGINE  
DRG NO: DRAWING-04  
JOB NO:  
CHK BY: R.KANNAN

**FOARCONS**  
FORUM ARCHITECTURAL CONSULTANTS  
NO#16ANGA FLATS,3/2#NAKKIRAN ST,  
WEST MAMBALAM,CHENNAI - 600 033.  
PH:044 24812179, CELL-9381034445.  
EMAIL ID: FOARCONS@YMAIL.COM





# FOR TENDER PURPOSE ONLY

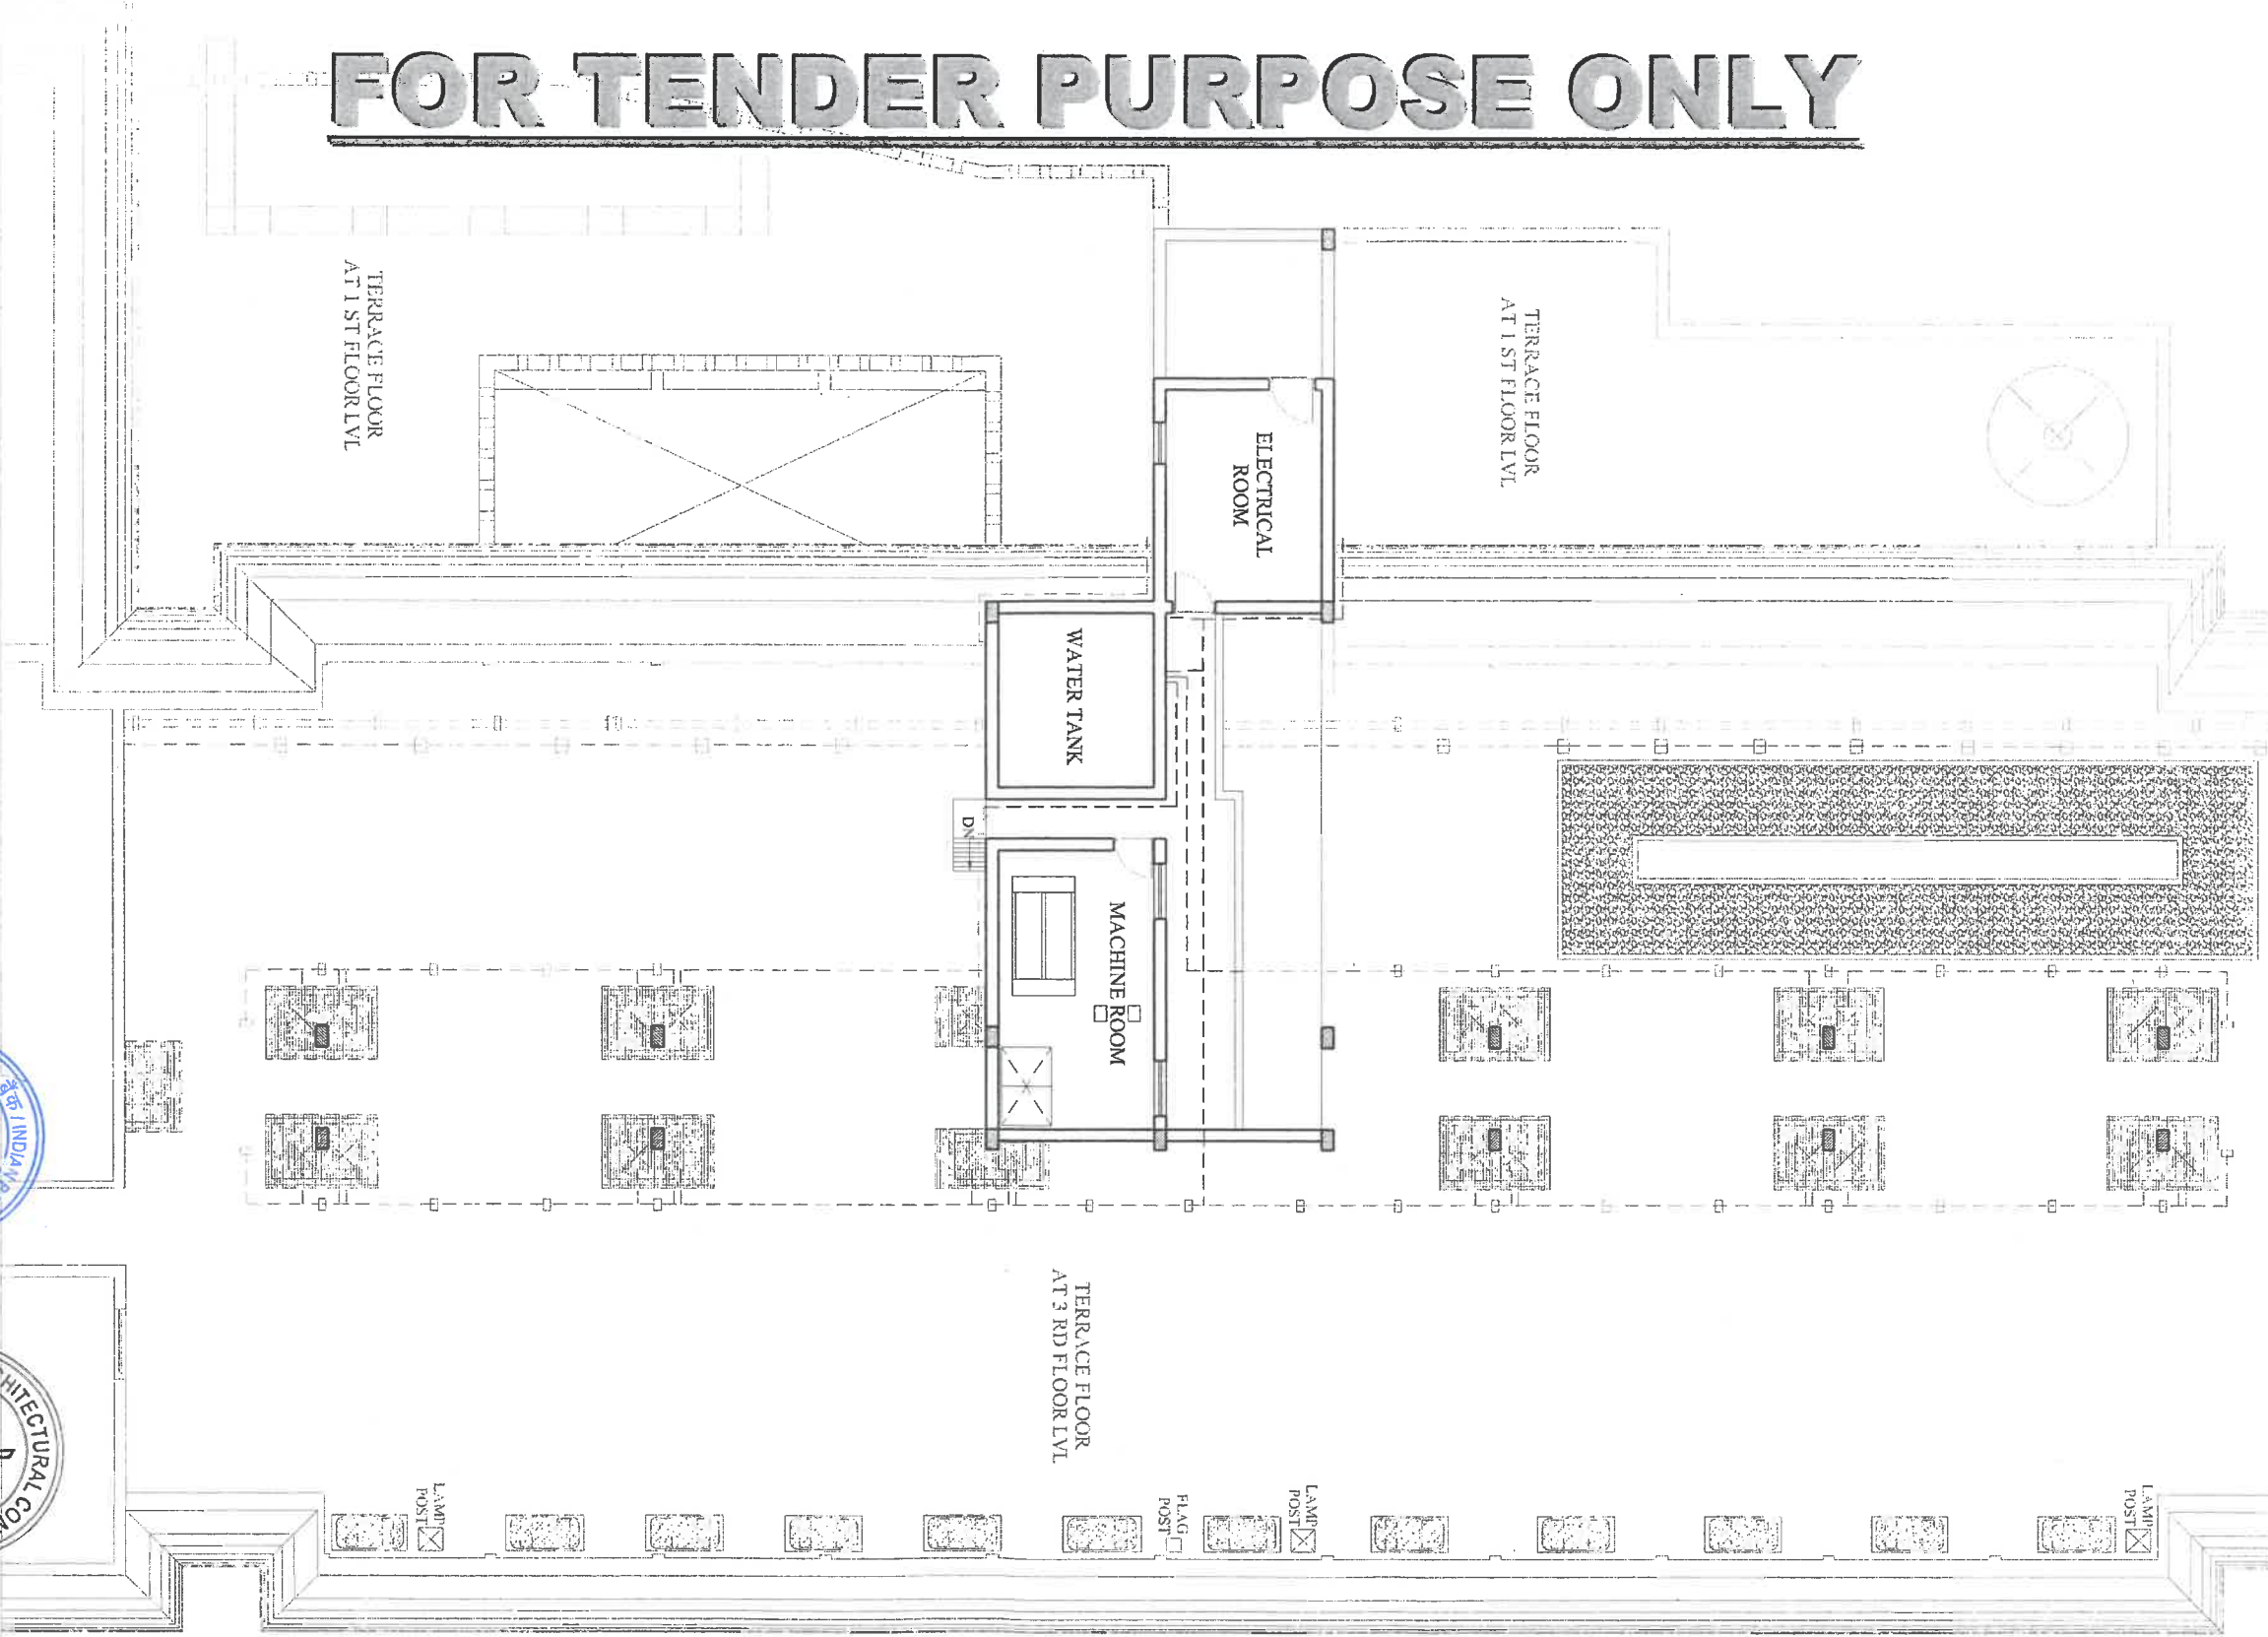

NOTE:  
THIS DRAWING OR DESIGN IS COPYRIGHT. IT IS THE PROPERTY OF THE ARCHITECTS OR DESIGNERS AND IS NOT TO BE REPRODUCED, COPIED OR HANDED OVER TO A THIRD PARTY OR USED FOR ANY PURPOSE OTHER THAN THAT FOR WHICH IT HAS BEEN ACTUALLY LOANED. READ THE DRAWING, DO NOT MEASURE IT. INFORM THE ARCHITECTS OR DESIGNERS OF ANY DISCREPANCIES IN THE DRAWING IMMEDIATELY.

PROJECT NAME:  
**HOSTEL ( RENOVATION )**  
CLIENT NAME:  
**INDIAN BANK**  
PLACE OF THE PROJECT:  
**CHENNAI.**

TITLE:-  
**EXISTING**  
**TERRACE 1**  
**FLOOR PLAN**


SCALE : 1"=12'6"/19'0"(A4)  
DATE : 21-08-2021  
DRN BY: EUGINE  
DRG NO: DRAWING-05  
JOB NO:  
CHK BY: R.KANNAN

**FOARCONS**  
FORUM ARCHITECTURAL CONSULTANTS  
NO#16 ANGAS FLATS, 3/2#NAKKIRAN ST,  
WEST MAMBALAM, CHENNAI - 600 033.  
Ph: 044 24812179, CELL-9381034445.  
EMAIL ID: FOARCONS@YMAIL.COM



*R. Kannan*

FOR TENDER PURPOSE ONLY

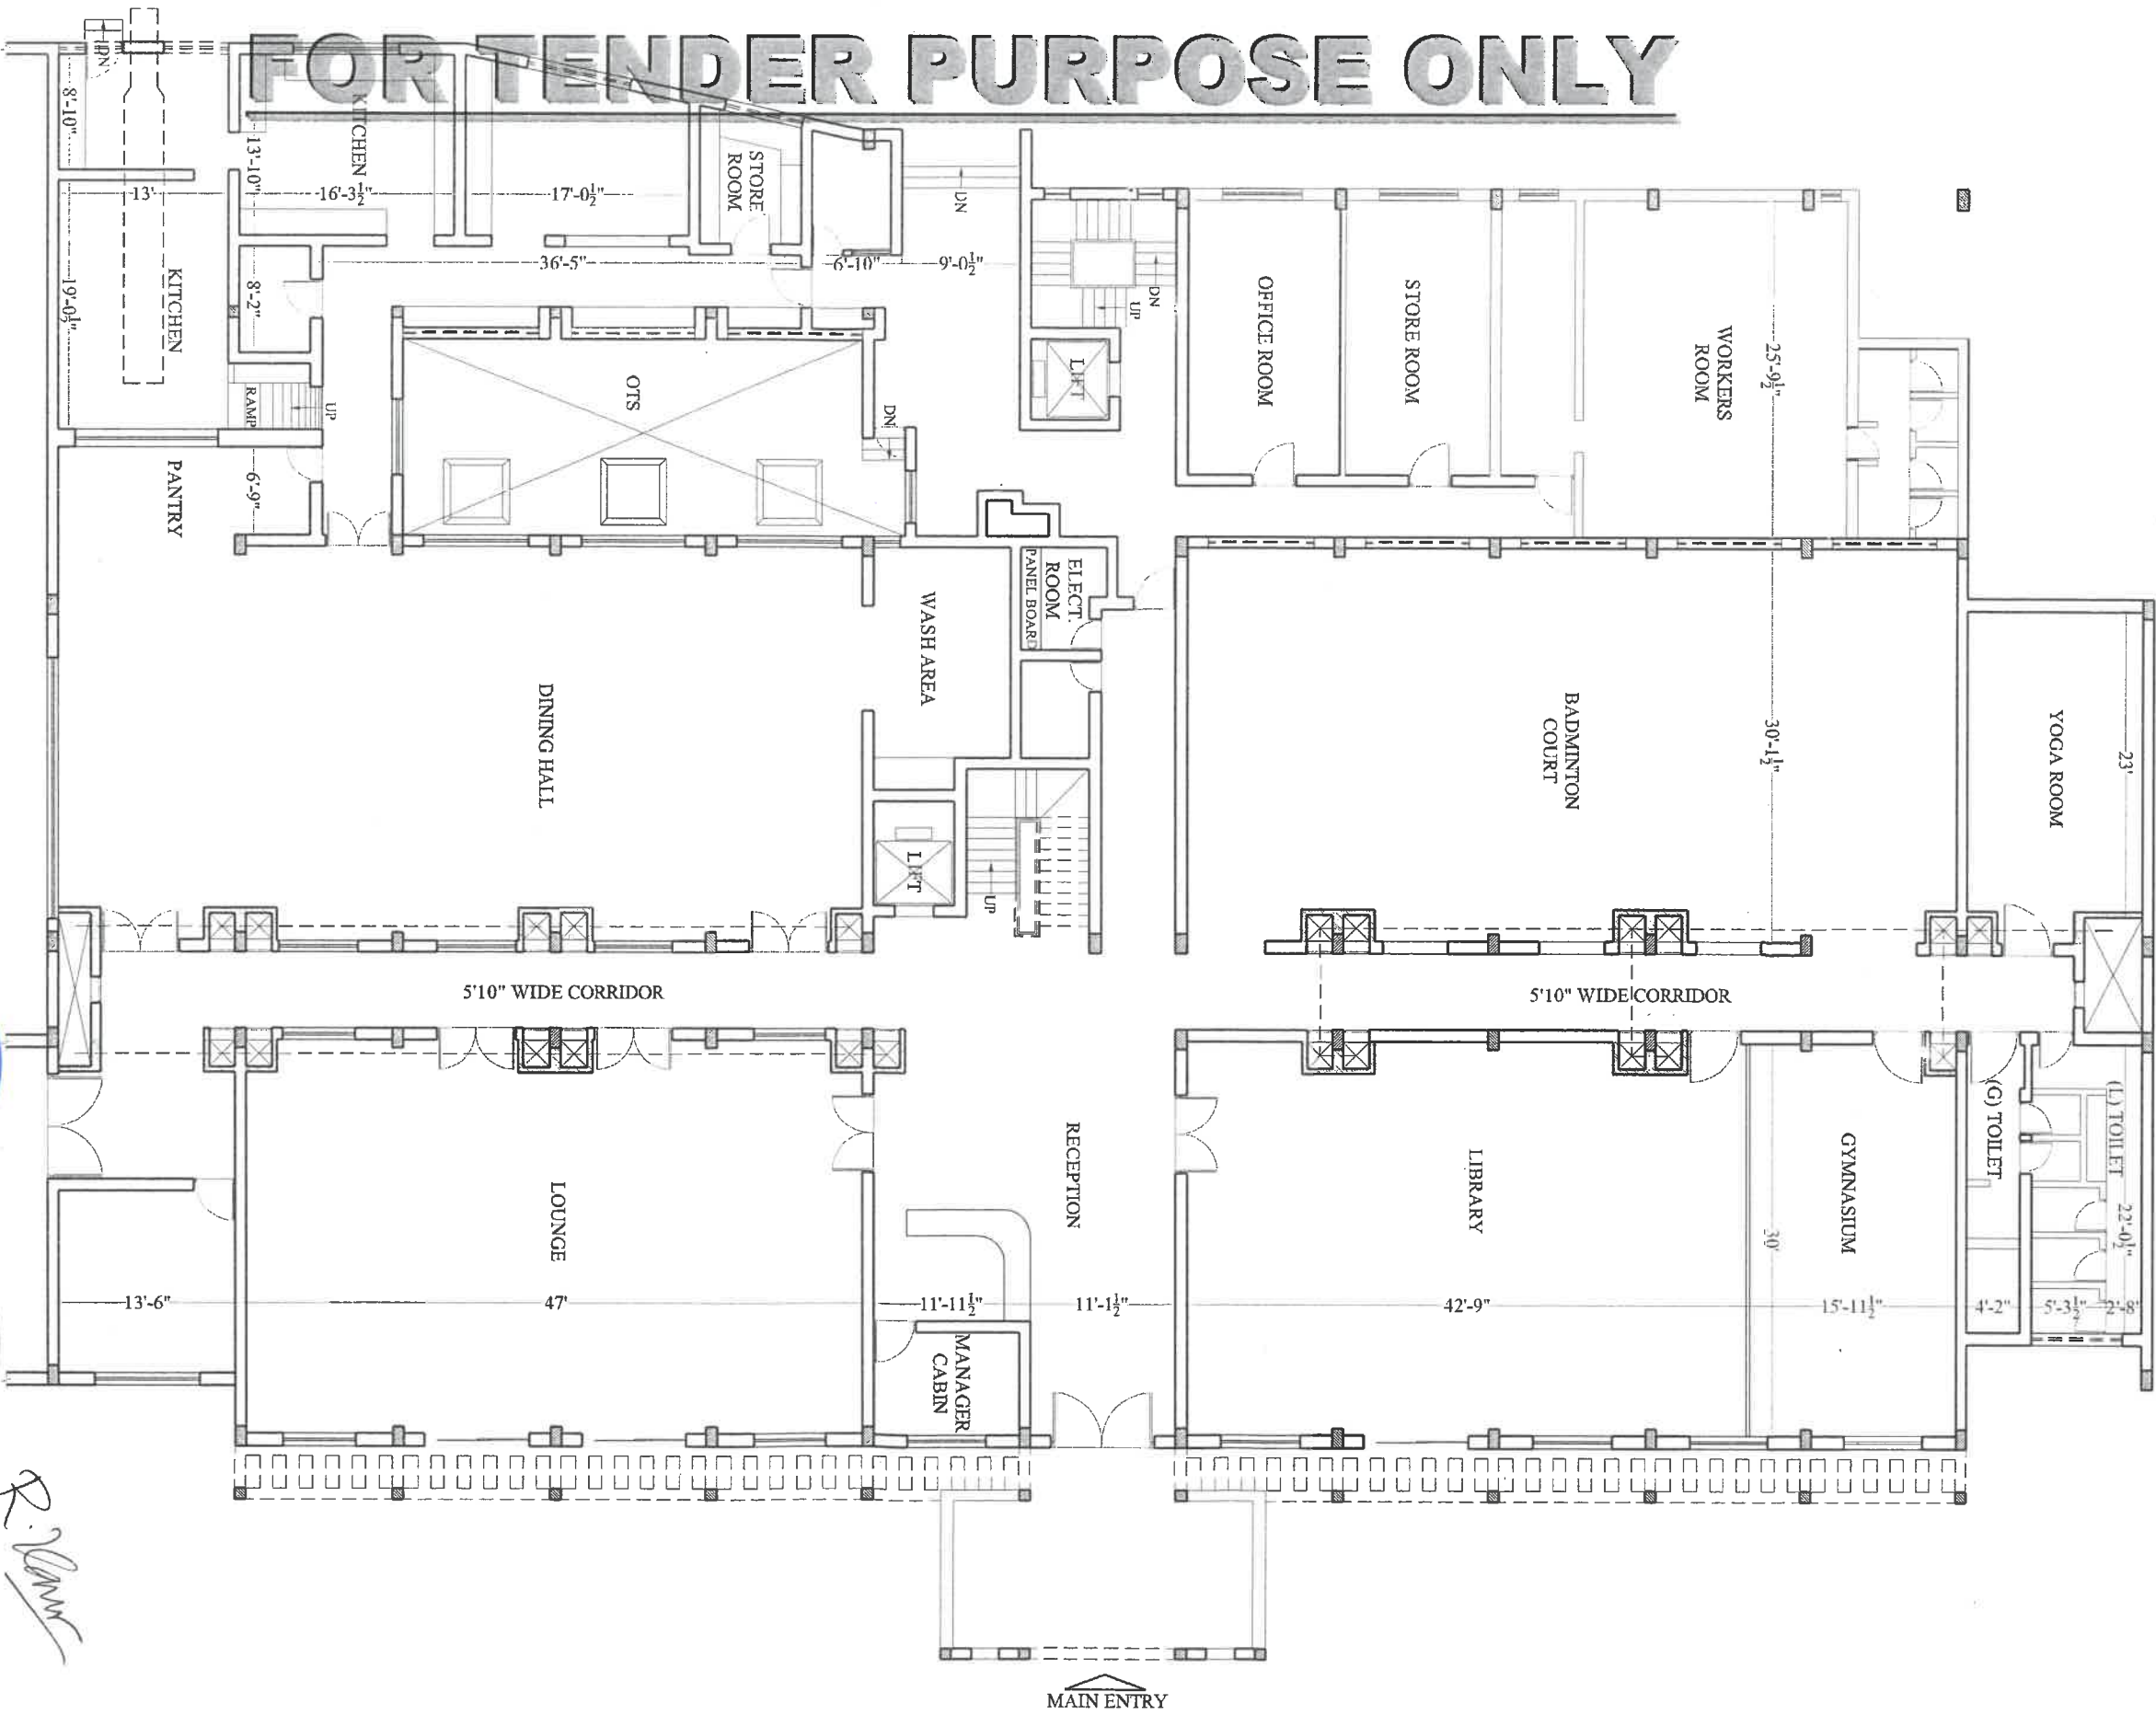

PROPOSED WALL

R. V. V. V.

NOTE:  
THIS DRAWING OR DESIGN IS COPYRIGHT. IT IS THE PROPERTY OF THE ARCHITECTS OR DESIGNERS AND IS NOT TO BE REPRODUCED COPIED OR HANDED OVER TO A THIRD PARTY OR USED FOR ANY PURPOSE OTHER THAN THAT FOR WHICH IT HAS BEEN ACTUALLY OBTAINED. READ THE DRAWING, DO NOT MEASURE ANY DISCREPANCIES IN THE DRAWING IMMEDIATELY.

PROJECT NAME:  
**HOSTEL( RENOVATION )**  
CLIENT NAME:  
**INDIAN BANK**  
PLACE OF THE PROJECT:  
**CHENNAI.**


TITLE:-  
**PROPOSED**  
**GROUND FLOOR PLAN**

SCALE : 1"=12'6"/19'0"(A4)  
DATE : 21-08-2021  
DRN BY: **EUGINE**  
DRG NO: **DRAWING-06**  
JOB NO:  
CHK BY: **R.KANNAN**

**FOARCONS**  
FORUM ARCHITECTURAL CONSULTANTS  
NO.4#GANGA FLATS,3/2#NAKKIRAN ST,  
WEST MAMBALAM,CHENNAI - 600 033.  
PH:044 24812179, CELL-9381034445.  
EMAIL ID: FOARCONS@YMAIL.COM



# FOR TENDER PURPOSE ONLY

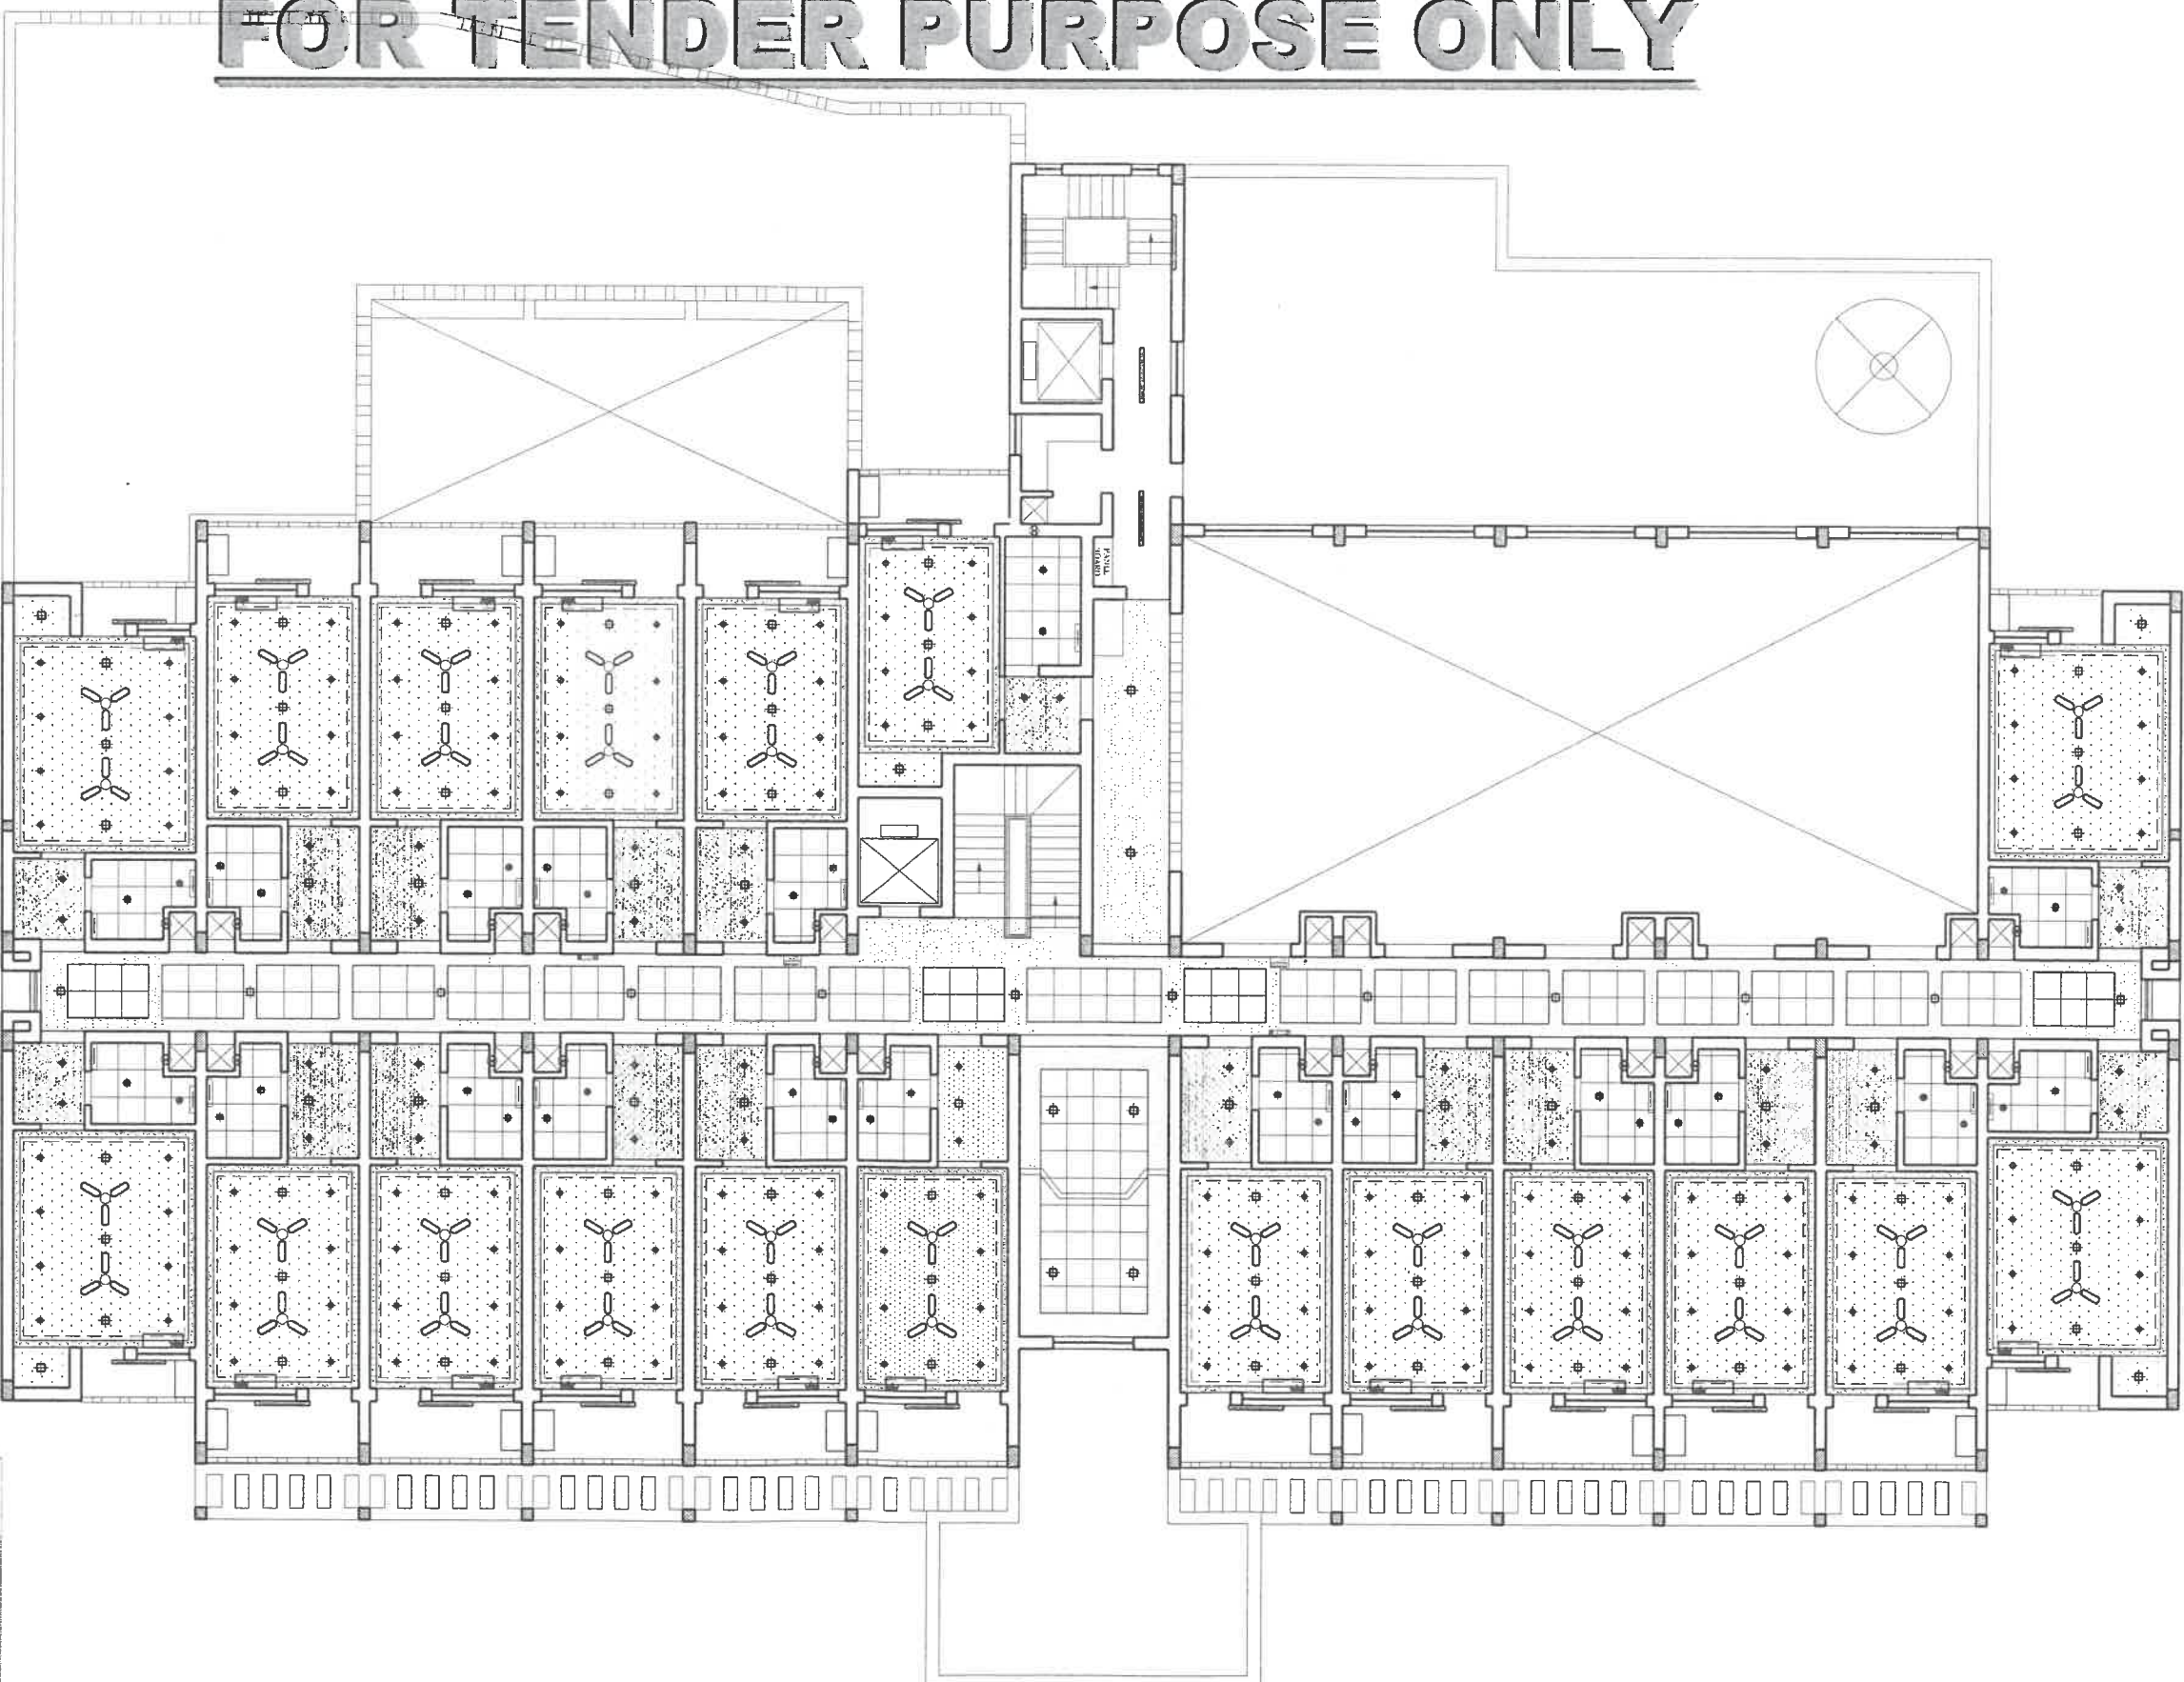

|   |                         |
|---|-------------------------|
| • | -LED 8.0<br>WATT LIGHT  |
| • | -LED 15.0<br>WATT LIGHT |
| • | -LED 6.0<br>WATT LIGHT  |
| • | -20 W LED LIGHT         |

NOTE:  
THIS DRAWING OR DESIGN IS COPYRIGHT. IT IS THE PROPERTY OF THE ARCHITECTS OR DESIGNERS AND IS NOT TO BE REPRODUCED, COPIED, OR HANDED OVER TO A THIRD PARTY OR USED FOR ANY PURPOSE OTHER THAN THAT FOR WHICH IT HAS BEEN ACTUALLY LOANED. READ THE DRAWING, DO NOT MEASURE IT. INFORM THE ARCHITECTS OR DESIGNERS OF ANY DISCREPANCIES IN THE DRAWING IMMEDIATELY.

PROJECT NAME:  
**HOSTEL ( RENOVATION )**  
CLIENT NAME:  
**INDIAN BANK**  
PLACE OF THE PROJECT:  
**CHENNAI.**


TITLE:-  
**FALSE CEILING  
LAYOUT  
FIRST FLOOR PLAN**  
A3-FORMAT-11.7"x16.5"

SCALE : 1"=126"190"(A4)  
DATE : 16-02-2022  
DRN BY: EUGINE  
DRG NO: DRAWING-07  
JOB NO:  
CHK BY: R.KANNAN


**FOARCONS**  
FORUM ARCHITECTURAL CONSULTANTS  
NO#16 Ganga Flats, 3/2# NAKKIRAN ST,  
WEST MAMBALAM, CHENNAI - 600 033.  
PH: 044 24812179, CELL-9381034445.  
EMAIL ID: FOARCONS@YMAIL.COM



# FOR TENDER PURPOSE ONLY

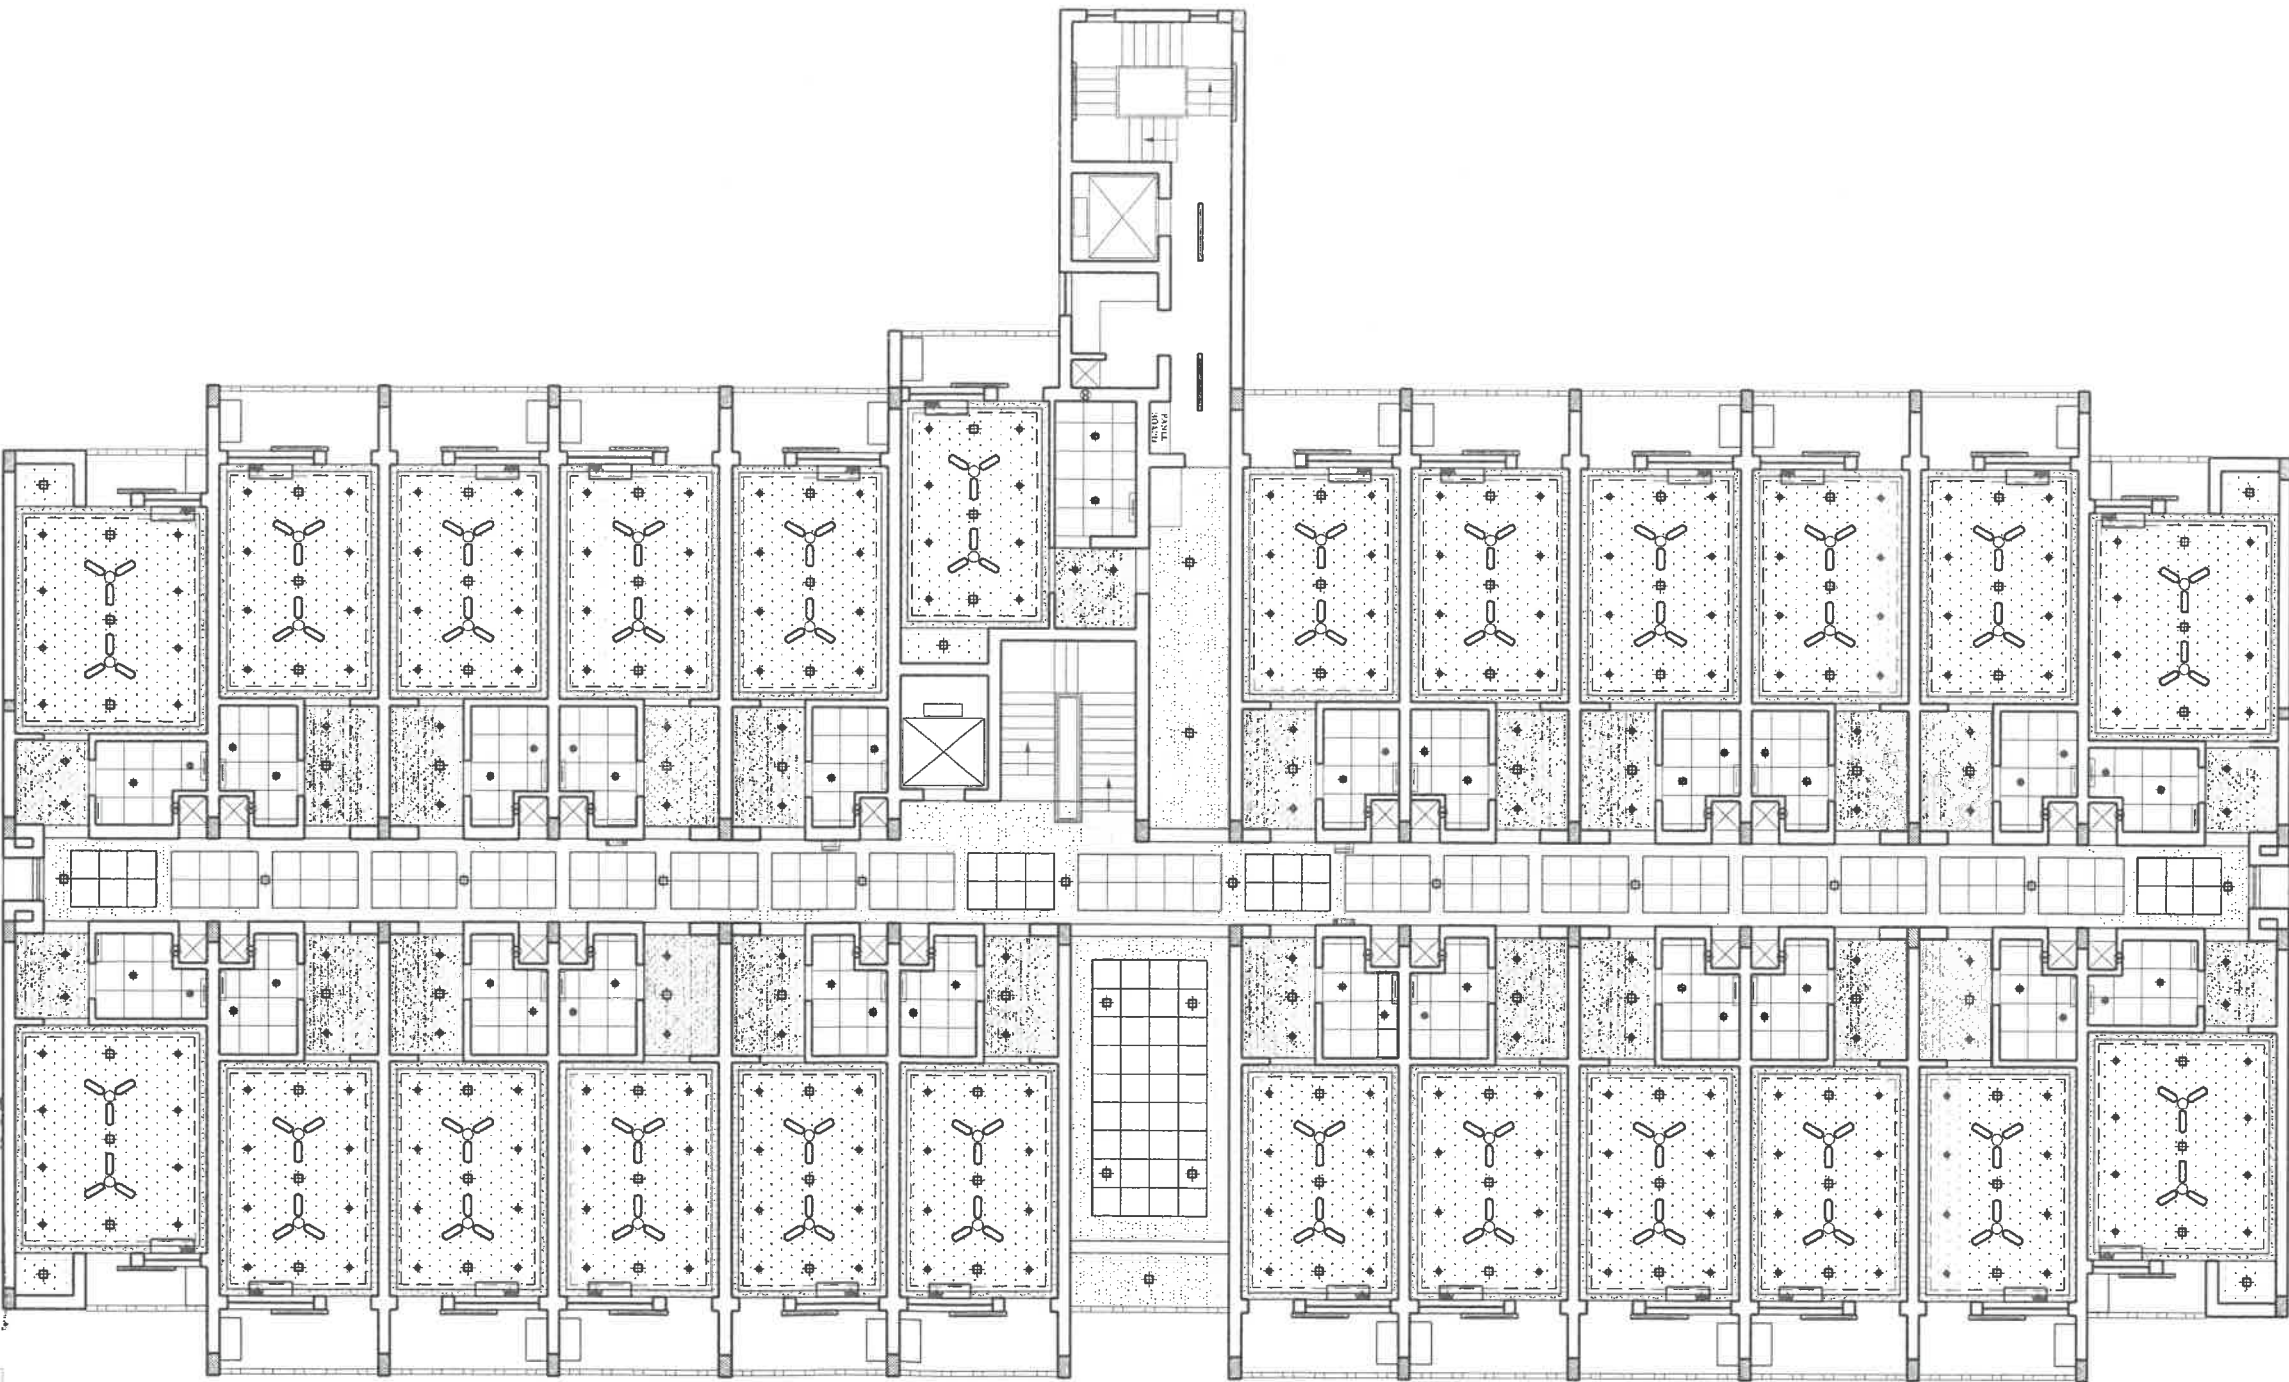

|   |                          |
|---|--------------------------|
| • | - LED 8.0<br>WATT LIGHT  |
| • | - LED 15.0<br>WATT LIGHT |
| • | - LED 6.0<br>WATT LIGHT  |
| • | - 20 W LED LIGHT         |

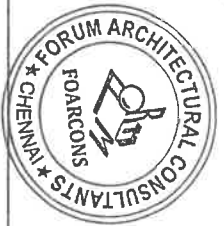

R. Kannan

CHK BY: R.KANNAN

NOTE:  
THIS DRAWING OR DESIGN IS COPYRIGHT. IT IS THE PROPERTY OF THE ARCHITECTS OR DESIGNERS AND IS NOT TO BE REPRODUCED COPIED OR HANDED OVER TO A THIRD PARTY OR USED FOR ANY PURPOSE OTHER THAN THAT FOR WHICH IT HAS BEEN ACTUALLY OBTAINED. READ THE DRAWING, DO NOT MEASURE IT. INFORM THE ARCHITECTS OR DESIGNERS OF ANY DISCREPANCIES IN THE DRAWING IMMEDIATELY.


PROJECT NAME:  
**HOSTEL( RENOVATION )**  
CLIENT NAME:  
**INDIAN BANK**  
PLACE OF THE PROJECT:  
**CHENNAI.**

TITLE:-  
**FALSE CEILING  
LAYOUT**  
**2nd & 3rd FLOOR PLAN**  
A3-FORMAT-11.7"x16.5"


SCALE : 1"=12'6"/19'0"(A4)  
DATE : 16-02-2022  
DRN BY: EUGINE  
DRG NO: DRAWING-08  
JOB NO:  
CHK BY: R.KANNAN

**FOARCONS**  
FORUM ARCHITECTURAL CONSULTANTS  
NO#GANGA FLATS,312#NAKKIRAN ST,  
WEST MAMBALAM,CHENNAI - 600 033.  
PH:044 24812179, CELL-9381034445.  
EMAIL ID: FOARCONS@YMAIL.COM



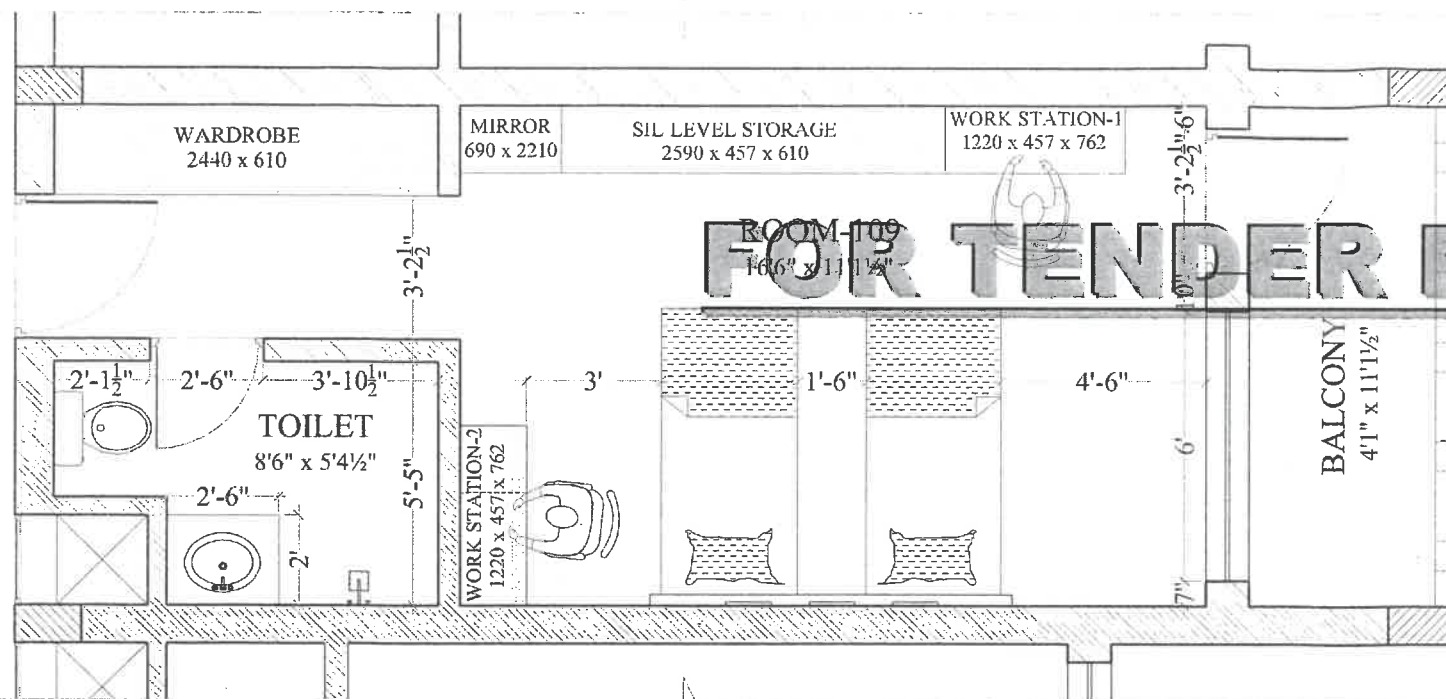


PLAN OF ROOM -109

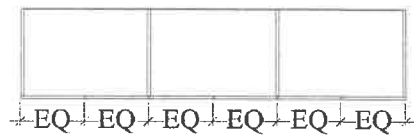


PLAN OF WARDROBE  
(2591 x 610 x 2440)

NOTE: 18mm TK PLYWOOD  
WARDROBE : Regular 8" HANDLE  
LAMINATE : 753 sd - ASIS

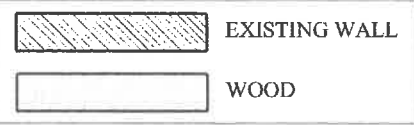


LEGEND:


|  |                       |    |
|--|-----------------------|----|
|  | - LED 8.0 WATT LIGHT  | 02 |
|  | - LED 15.0 WATT LIGHT | 04 |
|  | - LED 6.0 WATT LIGHT  | 10 |
|  | - 9W LED LIGHT        | 01 |
|  | - 20W LED LIGHT       | 01 |
|  | - EXHAUST FAN         | 01 |
|  | - 48" CEILING FAN     | 02 |

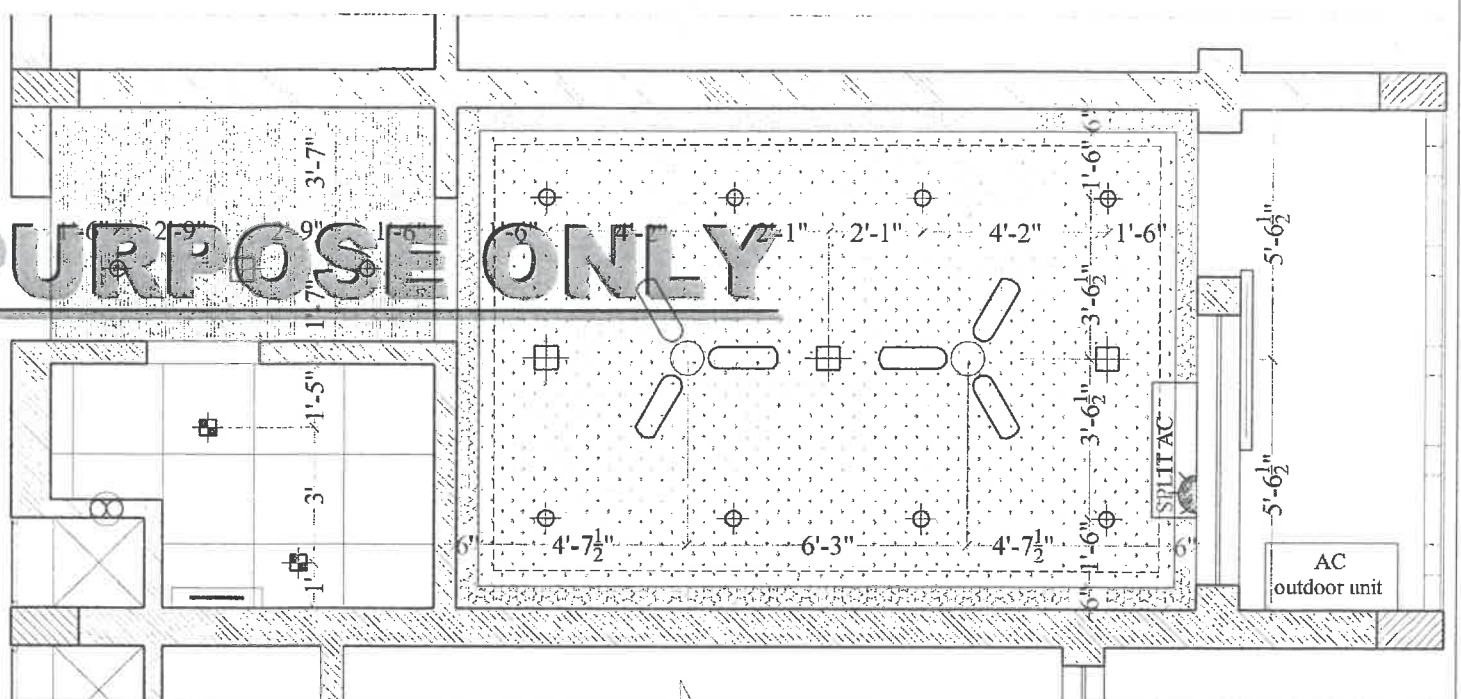

PLAN OF ROOM -109 - FALSE CEILING LAYOUT

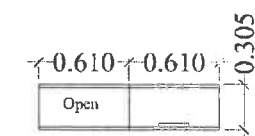

EXTERNAL ELEVATION

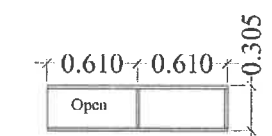


INTERNAL ELEVATION


|  |                                        |
|--|----------------------------------------|
|  | GRID FALSE CEILING (@ + 7'6" LVL)      |
|  | GYPSUM BOARD FALSE CEILING (@ + 8'0")  |
|  | GYPSUM BOARD FALSE CEILING (@ + 8'6")  |
|  | GYPSUM BOARD FALSE CEILING (@ + 8'10") |

NOTE: 18mm TK PLYWOOD  
TV Base unit : 25mm TK TOP PLY  
Study table : 25mm TK TOP PLY  
LAMINATE : 753 sd, 102 sd

WORK STATION - 2

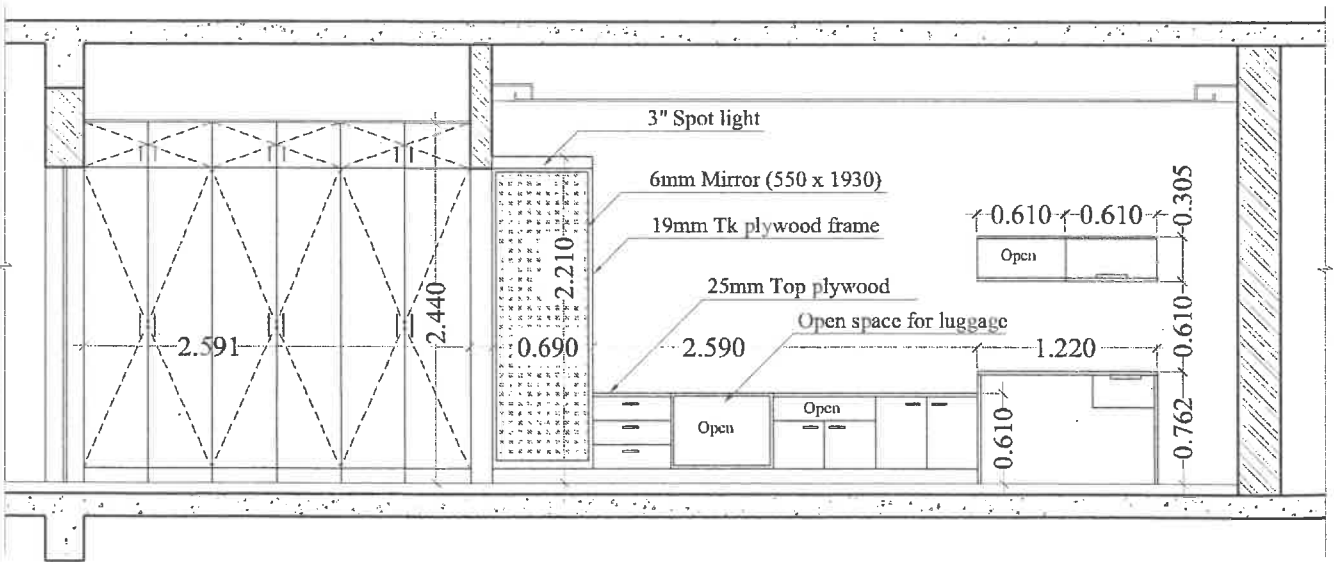

EXTERNAL ELEVATION

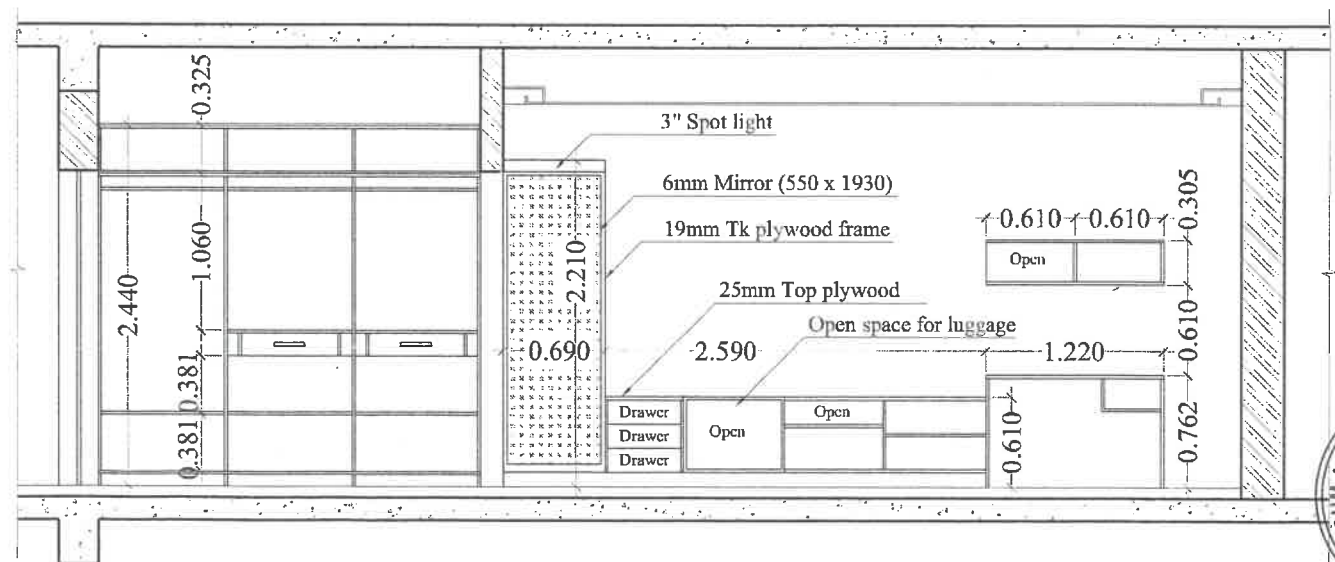

INTERNAL ELEVATION

NOTE:  
THIS DRAWING OR DESIGN IS COPYRIGHT. IT IS THE PROPERTY OF THE ARCHITECTS OR DESIGNERS AND IS NOT TO BE REPRODUCED, COPIED OR HANDED OVER TO A THIRD PARTY OR USED FOR ANY PURPOSE OTHER THAN THAT FOR WHICH IT HAS BEEN ACTUALLY LOANED. READ THE DRAWING, DO NOT MEASURE IT. INFORM THE ARCHITECTS OR DESIGNERS OF ANY DISCREPANCIES IN THE DRAWING IMMEDIATELY.

PROJECT NAME:  
**INTERIOR LAYOUT (HOSTEL RENOVATION)**  
CLIENT NAME:  
**INDIAN BANK**  
PLACE OF THE PROJECT:  
**CHENNAI.**



TITLE:-  
**PROPOSED  
INTERIOR LAYOUT  
ROOM-109**  
A3-FORMAT-16.5"x11.7"


SCALE : 1"=5'3"/8'0"(A4)  
DATE : 16-02-2022  
DRN BY: EUGINE  
DRG NO: DRAWING-09  
JOB NO:  
CHK BY: R.KANNAN

**FOARCONS**


FORUM ARCHITECTURAL CONSULTANTS  
NO#IGANGA FLATS, 3/2#NAKKIRAN ST.  
WEST MAMBALAM, CHENNAI - 600 033.  
PH: 044 24812179, CELL-9381034445.  
EMAIL ID: FOARCONS@YMAIL.COM





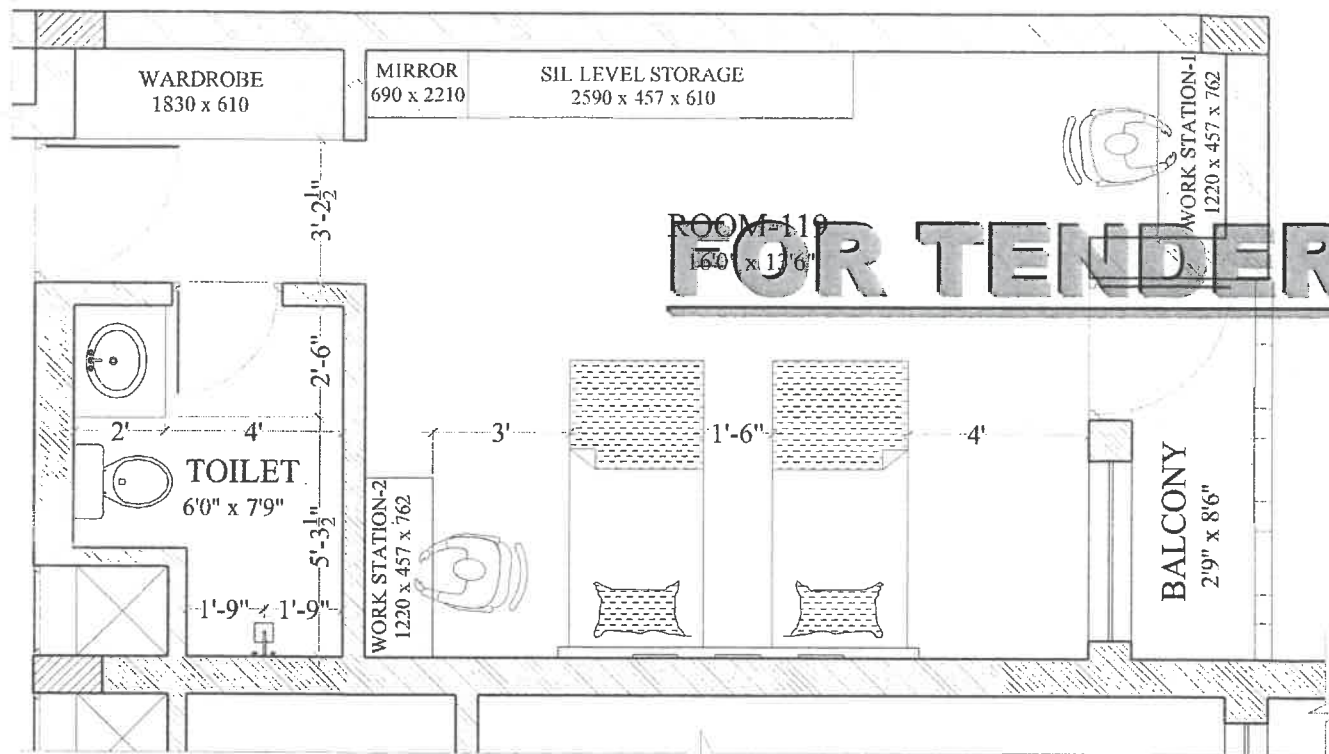


PLAN OF ROOM -119

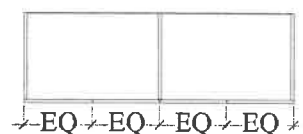


PLAN OF WARDROBE  
(1830 x 610 x 2440)

NOTE: 18mm TK PLYWOOD  
WARDROBE : Regular 8" HANDLE  
LAMINATE : 753 sd - ASIS

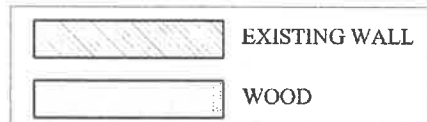

LEGEND:


|  |                       |    |
|--|-----------------------|----|
|  | - LED 8.0 WATT LIGHT  | 02 |
|  | - LED 15.0 WATT LIGHT | 04 |
|  | - LED 6.0 WATT LIGHT  | 10 |
|  | - 9W LED LIGHT        | 01 |
|  | - 20W LED LIGHT       | 01 |
|  | - EXHAUST FAN         | 01 |
|  | - 48" CEILING FAN     | 02 |

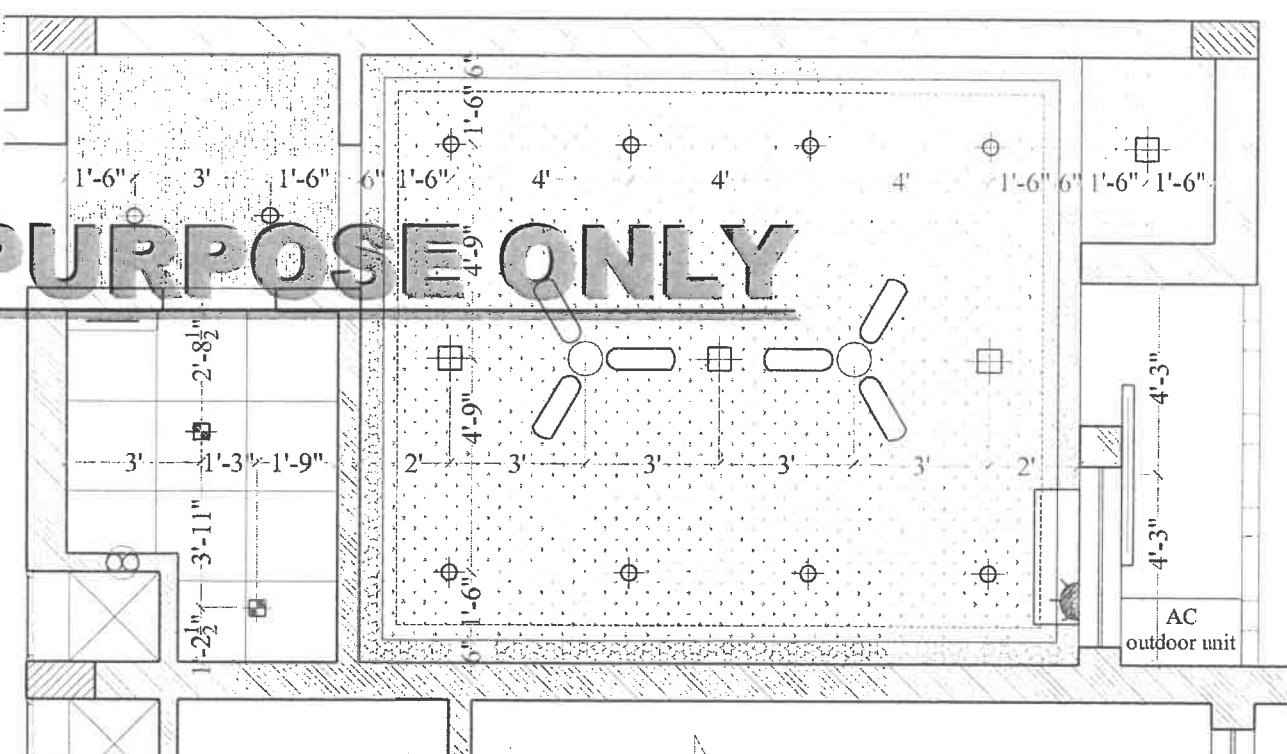


PLAN OF ROOM -119 - FALSE CEILING LAYOUT

|  |                                        |
|--|----------------------------------------|
|  | GRID FALSE CEILING (@ + 7'6" LVL)      |
|  | GYPSUM BOARD FALSE CEILING (@ + 8'0")  |
|  | GYPSUM BOARD FALSE CEILING (@ + 8'6")  |
|  | GYPSUM BOARD FALSE CEILING (@ + 8'10") |

NOTE: 18mm TK PLYWOOD  
TV Base unit : 25mm TK TOP PLY  
Study table : 25mm TK TOP PLY

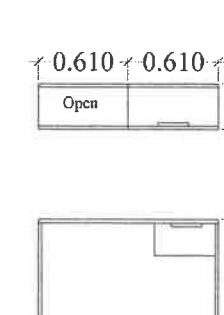


EXTERNAL ELEVATION

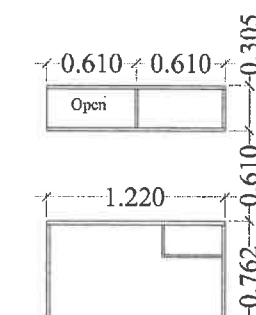


INTERNAL ELEVATION

WORK STATION - 2

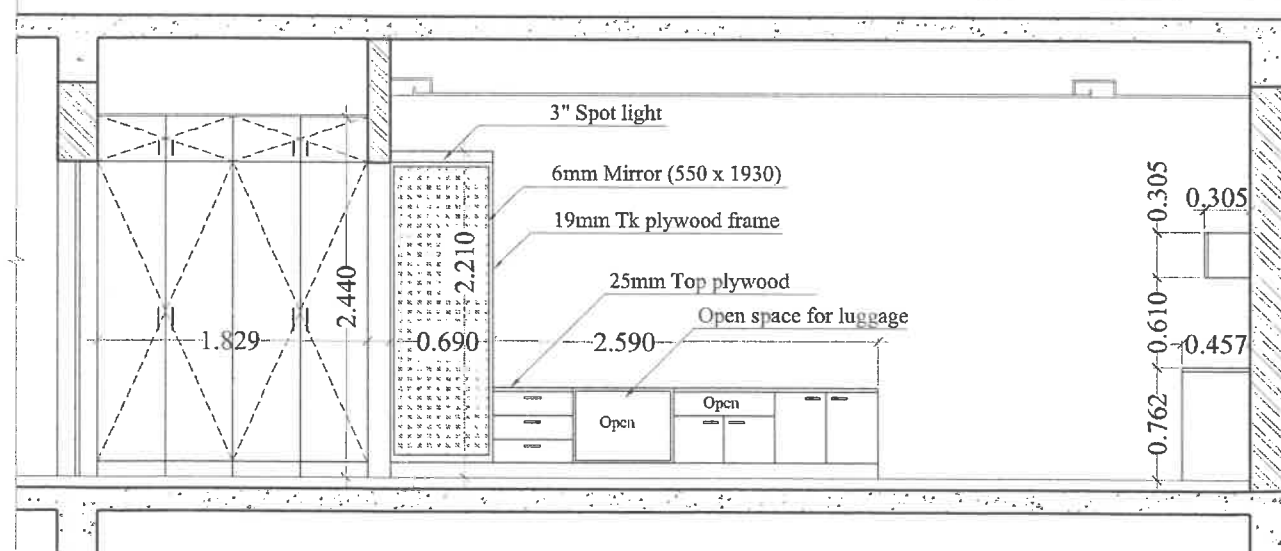


EXTERNAL ELEVATION

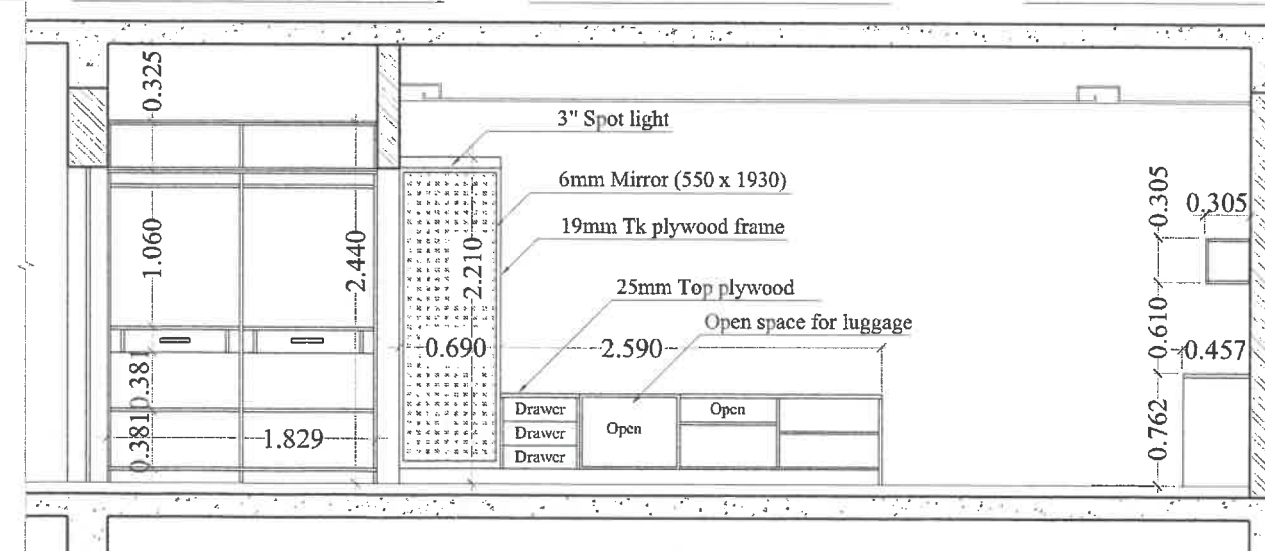

INTERNAL ELEVATION

R. Kannan

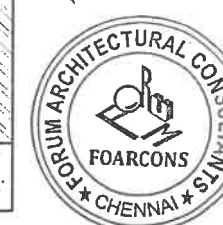

NOTE:  
THIS DRAWING OR DESIGN IS COPYRIGHT. IT IS THE PROPERTY OF THE ARCHITECTS OR DESIGNERS AND IS NOT TO BE REPRODUCED, COPIED OR HANDED OVER TO A THIRD PARTY OR USED FOR ANY PURPOSE OTHER THAN THAT FOR WHICH IT HAS BEEN ACTUALLY LOANED. READ THE DRAWING, DO NOT MEASURE IT. INFORM THE ARCHITECTS OR DESIGNERS OF ANY DISCREPANCIES IN THE DRAWING IMMEDIATELY.

PROJECT NAME:  
**INTERIOR LAYOUT (HOSTEL RENOVATION)**  
CLIENT NAME:  
**INDIAN BANK**  
PLACE OF THE PROJECT:  
**CHENNAI.**



TITLE:-  
PROPOSED  
INTERIOR LAYOUT  
ROOM-119  
A3-FORMAT-16.5"x11.7"

SCALE : 1"=5'3"/8'0"(A4)  
DATE : 16-02-2022  
DRN BY: EUGINE  
DRG NO: DRAWING-10  
JOB NO:  
CHK BY: R.KANNAN

**FOARCONS**  
FORUM ARCHITECTURAL CONSULTANTS  
NO#1GANGA PLATS,3/2#NAKKIRAN ST,  
WEST MAMBALAM,CHENNAI - 600 033.  
PH:044 24812179, CELL-9381034445.  
EMAIL ID: FOARCONS@YMAIL.COM





FROM ELECTRICITY BOARD

ELECTRICAL ROOM - GROUND FLOOR

12W PANEL BOARD / 500A ALUMINUM BUSBAR

500A ALUMINUM BUSBAR

400A  
4P changer over SWITCH  
Existing Cable

400A 4P MCCB

250A 4P  
MCCB

250A 4P  
MCCB

250A 4P  
MCCB

250A 4P  
MCCB

63A 4P  
MCCB

63A 4P  
MCCB

3.5C x 70 sq.mm  
Armoured aluminium cable

3.5C x 70 sq.mm  
Armoured aluminium cable

3.5C x 70 sq.mm  
Armoured aluminium cable

PANEL BOARD - FIRST FLOOR

6W SUB MAIN DISTRIBUTION BOARD

250A 4P MCCB

160A 4P  
MCCB

63A 4P  
MCCB

160A 4P  
MCCB

160A 4P  
MCCB

63A 4P  
MCCB

63A 4P  
MCCB

SPARE

SPARE

12W VTPN MCCB DB  
PDB-1  
LEFT SIDE CORRIDOR -  
FIRST FLOOR

6W TPN MCB DB  
LDB-1  
LEFT SIDE CORRIDOR -  
FIRST FLOOR

6W VTPN MCCB DB  
PDB-2  
RIGHT SIDE CORRIDOR -  
FIRST FLOOR

6W TPN MCB DB  
LDB-2  
RIGHT SIDE CORRIDOR -  
FIRST FLOOR

PANEL BOARD - SECOND FLOOR

6W SUB MAIN DISTRIBUTION BOARD

250A 4P MCCB

160A 4P  
MCCB

63A 4P  
MCCB

160A 4P  
MCCB

160A 4P  
MCCB

63A 4P  
MCCB

63A 4P  
MCCB

SPARE

SPARE

12W VTPN MCCB DB  
PDB-1  
LEFT SIDE CORRIDOR -  
SECOND FLOOR

6W TPN MCB DB  
LDB-1  
LEFT SIDE CORRIDOR -  
SECOND FLOOR

12W VTPN MCCB DB  
PDB-2  
RIGHT SIDE CORRIDOR -  
SECOND FLOOR

6W TPN MCB DB  
LDB-2  
RIGHT SIDE CORRIDOR -  
SECOND FLOOR

PANEL BOARD - THIRD FLOOR

6W SUB MAIN DISTRIBUTION BOARD

250A 4P MCCB

160A 4P  
MCCB

63A 4P  
MCCB

160A 4P  
MCCB

160A 4P  
MCCB

63A 4P  
MCCB

63A 4P  
MCCB

SPARE

SPARE

12W VTPN MCCB DB  
PDB-1  
LEFT SIDE CORRIDOR -  
THIRD FLOOR

6W TPN MCB DB  
LDB-1  
LEFT SIDE CORRIDOR -  
THIRD FLOOR

12W VTPN MCCB DB  
PDB-2  
RIGHT SIDE CORRIDOR -  
THIRD FLOOR

6W TPN MCB DB  
LDB-2  
RIGHT SIDE CORRIDOR -  
THIRD FLOOR

GROUND FLOOR DB'S

NOTE:  
THIS DRAWING OR DESIGN IS COPYRIGHT. IT IS THE PROPERTY OF THE ARCHITECTS OR DESIGNERS AND IS NOT TO BE REPRODUCED, COPIED OR HANDED OVER TO A THIRD PARTY OR USED FOR ANY PURPOSE OTHER THAN THAT FOR WHICH IT HAS BEEN ACTUALLY LOANED. READ THE DRAWING, DO NOT MEASURE IT. INFORM THE ARCHITECTS OR DESIGNERS OF ANY DISCREPANCIES IN THE DRAWING IMMEDIATELY.

PROJECT NAME:

HOSTEL( RENOVATION )

CLIENT NAME:

INDIAN BANK

PLACE OF THE PROJECT:

CHENNAI.



TITLE:-

PROPOSED  
SINGLE LINE DIAGRAM  
PART-1

A3-FORMAT-16.5"x11.7"

SCALE : 1" = 11'0"

DATE : 14-03-2022

DRN BY: EUGINE

DRG NO: DRAW-12-REV-2

JOB NO:

CHK BY: R.KANNAN

FOARCONS

FORUM ARCHITECTURAL CONSULTANTS  
NO#IGANGA FLATS, 3/2#NAKKIRAN ST,  
WEST MAMBALAM, CHENNAI - 600 033.  
PH: 044 24812179, CELL-9381034445.  
EMAIL ID: FOARCONS@YMAIL.COM




FROM - ELECTRICAL ROOM  
GROUND FLOOR  
12WPANEL BOARD / 500A COPPER BUSBAR


PANEL BOARD - SECOND FLOOR

6W SUB MAIN DISTRIBUTION BOARD


FOR TENDER PURPOSE ONLY

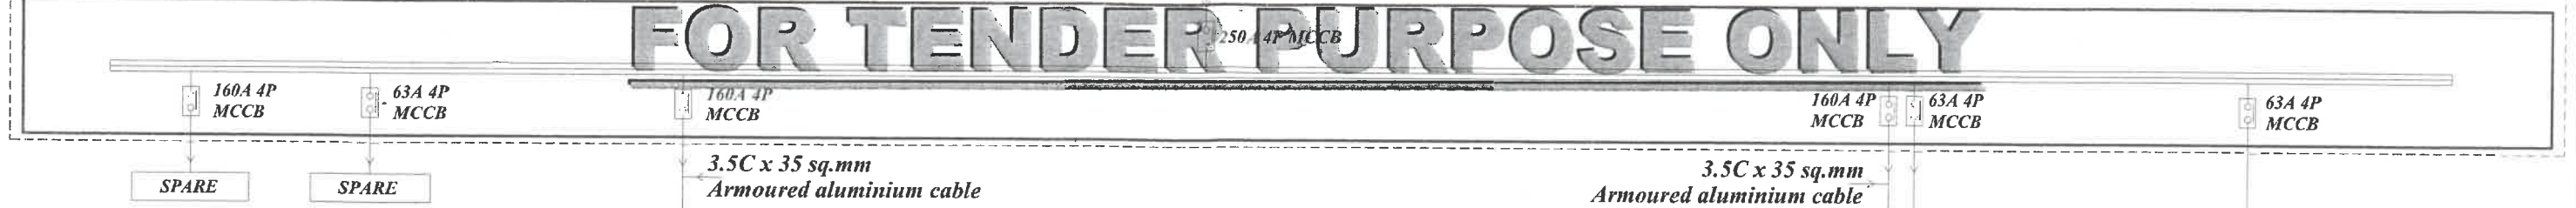

LEFT SIDE CORRIDOR - SECOND FLOOR

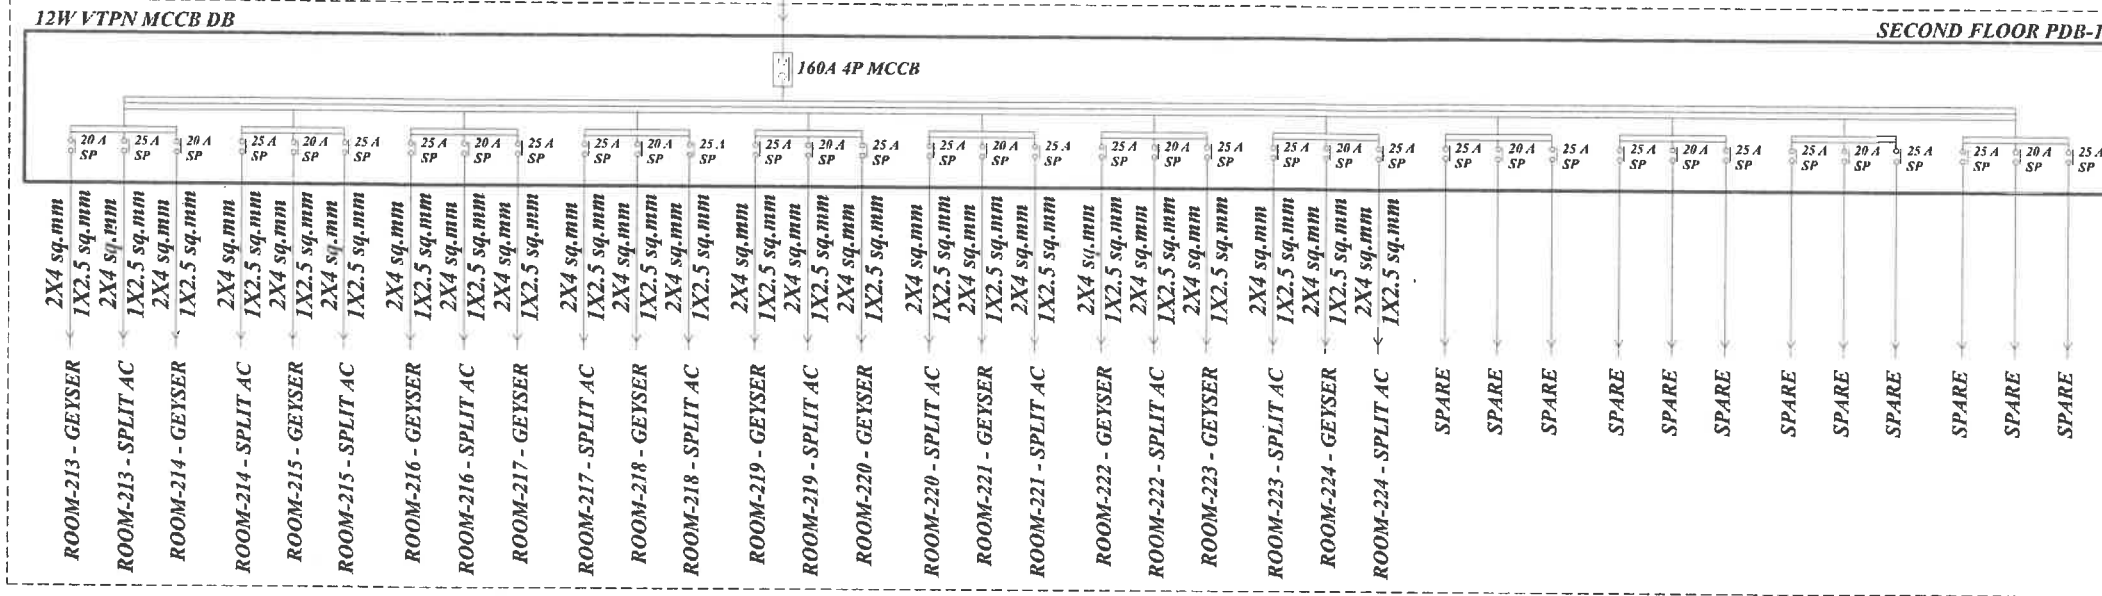


RIGHT SIDE CORRIDOR - SECOND FLOOR

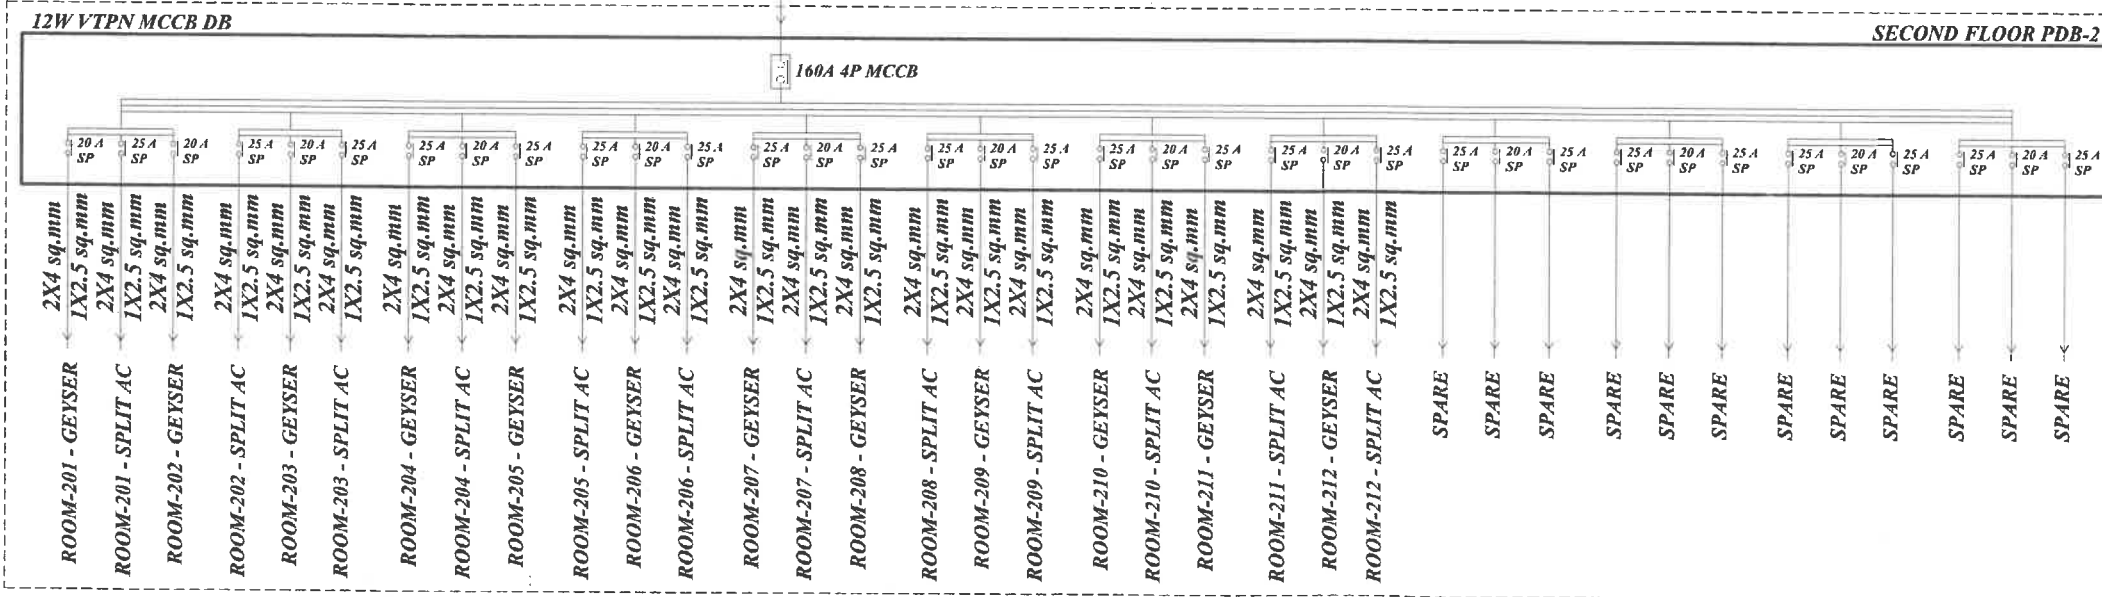


4C x 6 sq.mm  
Armoured copper cable

4C x 6 sq.mm  
Armoured copper cable

LEFT SIDE CORRIDOR  
SECOND FLOOR

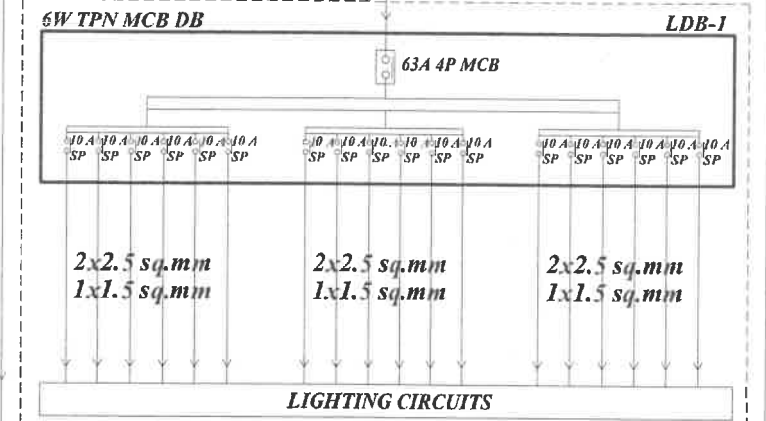

RIGHT SIDE CORRIDOR  
SECOND FLOOR

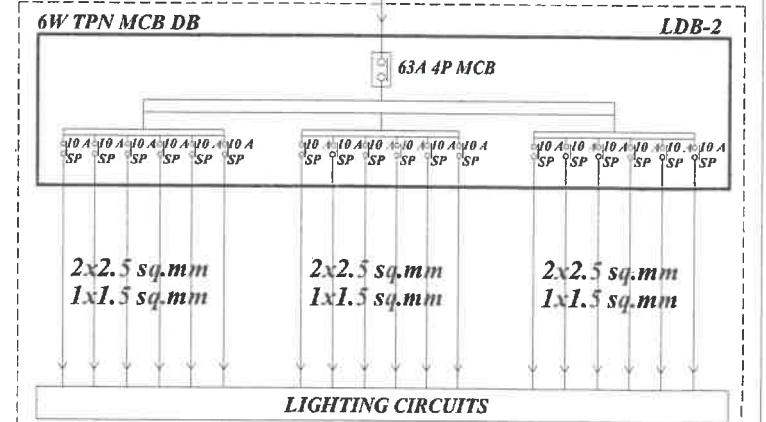

NOTE:  
THIS DRAWING OR DESIGN IS COPYRIGHT. IT IS THE PROPERTY OF THE ARCHITECTS OR DESIGNERS AND IS NOT TO BE REPRODUCED, COPIED OR HANDED OVER TO A THIRD PARTY OR USED FOR ANY PURPOSE OTHER THAN THAT FOR WHICH IT HAS BEEN ACTUALLY LOANED. READ THE DRAWING, DO NOT MEASURE IT. INFORM THE ARCHITECTS OR DESIGNERS OF ANY DISCREPANCIES IN THE DRAWING IMMEDIATELY.

PROJECT NAME:


HOSTEL( RENOVATION )

CLIENT NAME:

INDIAN BANK

PLACE OF THE PROJECT:

CHENNAI.

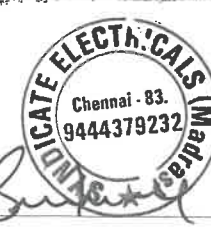

TITLE:-

PROPOSED  
SINGLE LINE DIAGRAM  
PART-2

A3-FORMAT-16.5"x11.7"

SCALE : 1" = 11'0"

DATE : 14-03-2022

DRN BY: EUGINE

DRG NO: DRAW-13-REV-2

JOB NO:

CHK BY: R.KANNAN

FOARCONS

FORUM ARCHITECTURAL CONSULTANTS  
NO#IGANGA FLATS,3/2#NAKKIRAN ST,  
WEST MAMBALAM,CHENNAI - 600 033.  
PH:044 24812179, CELL-9381034445.  
EMAIL ID: FOARCONS@YMAIL.COM