


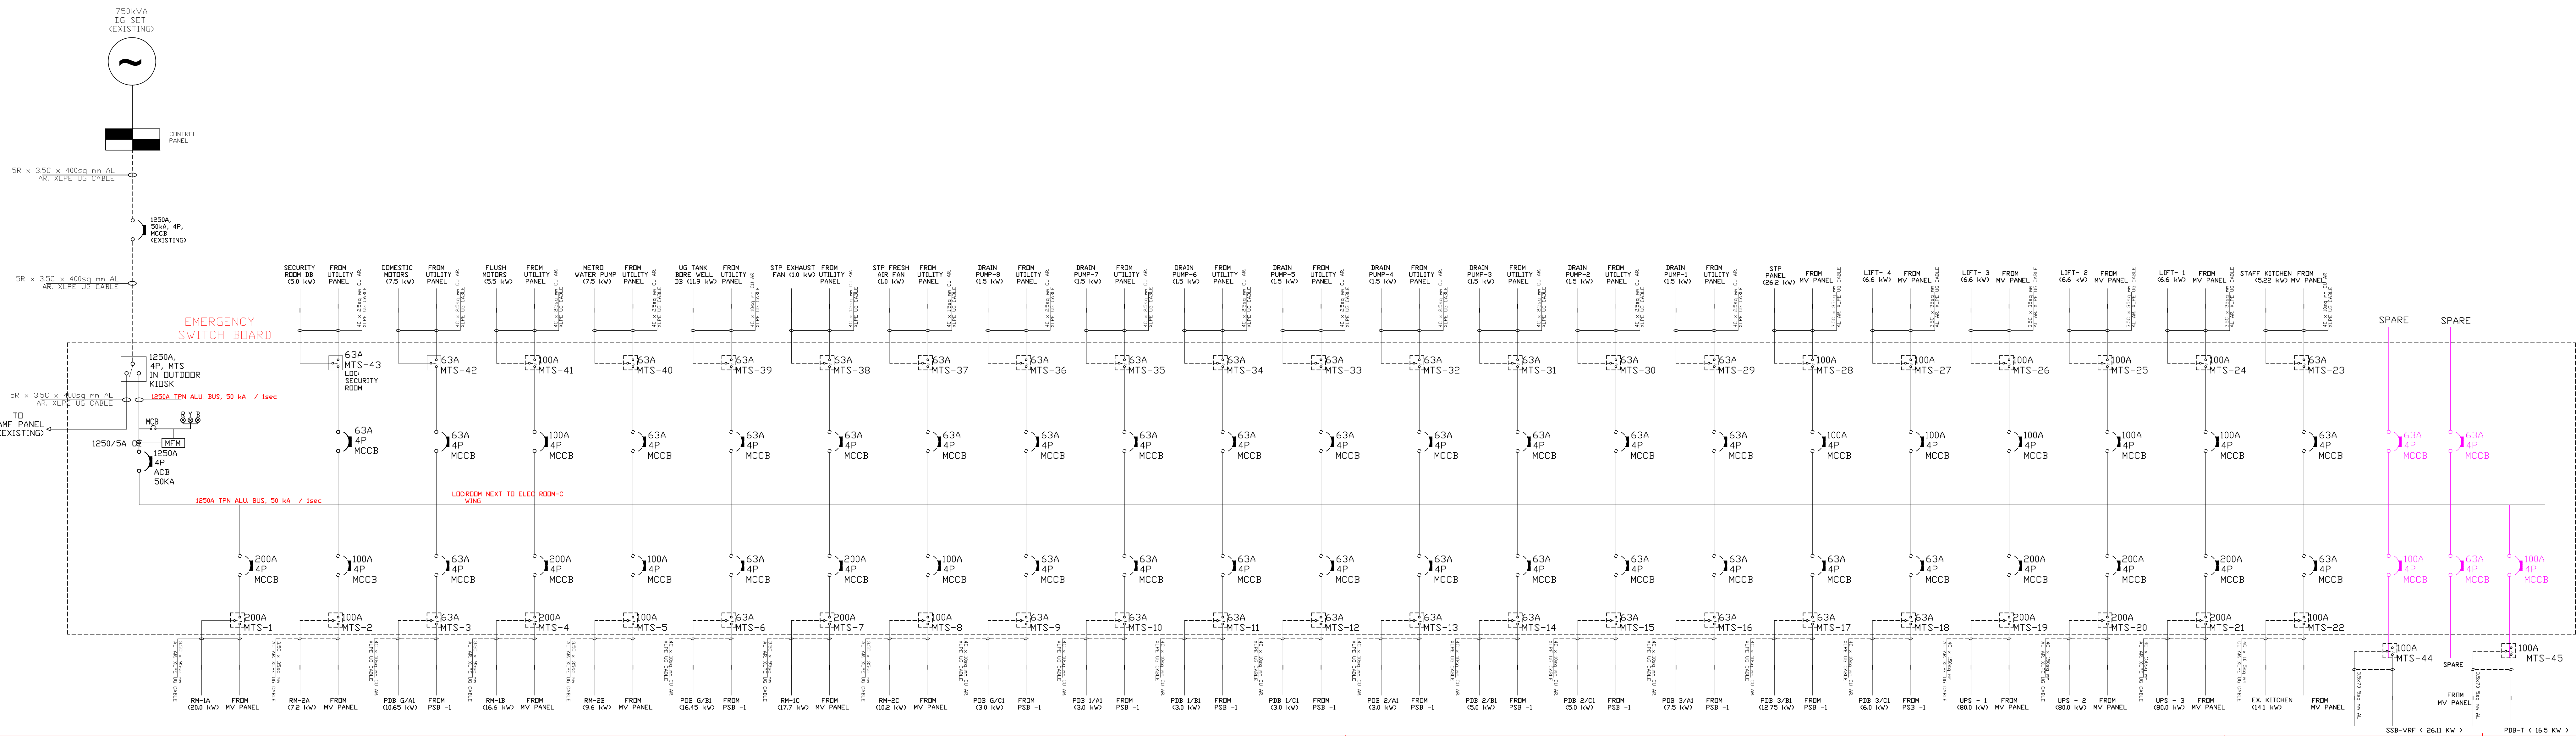

TITLE : SINGLE LINE DIAGRAM FOR EMERGENCY POWER SUPPLY SYSTEM
AT INDIAN BANK, CORPORATE OFFICE CHENNAI.

ELECTRICAL CONSULTANT:-

M/s. ENERGY MULTIPLES
Er. K.P.MURALIDHARAN.

DRAWN BY:	SNJ	APP BY:	
DATE :	17.08.24	DATE :	