


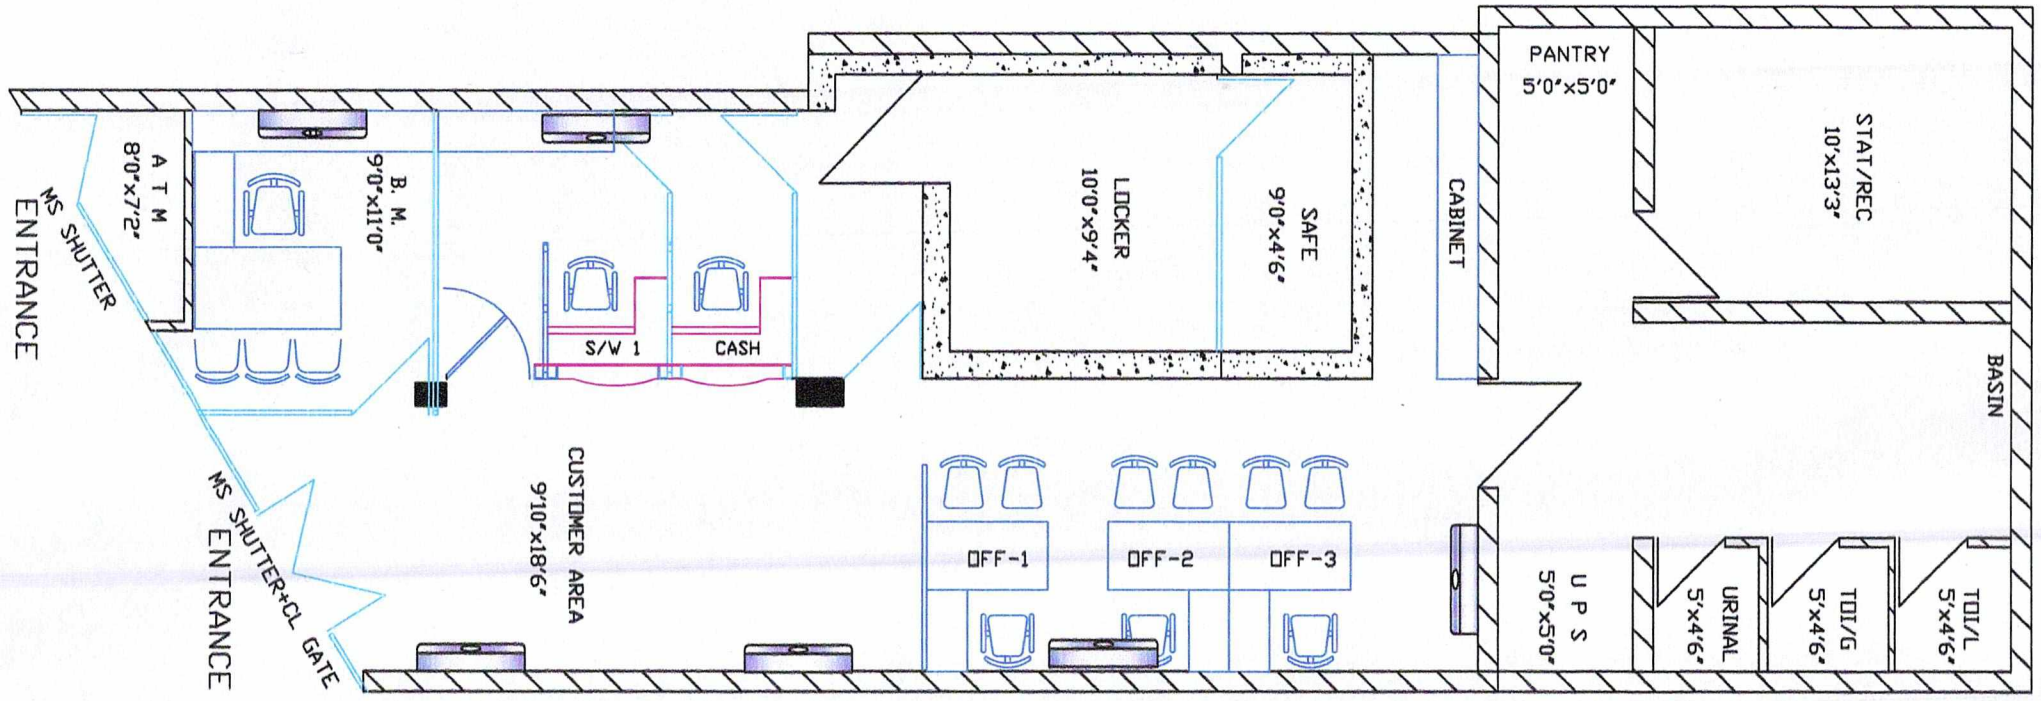

NICON INDIA
34, GURUKUL COMPLEX,
KALIBADI ROAD, RAIPUR. (C.G.)
MOB: 9826323237, 9827158700

TITLE :
A/C LAYOUT


DRG. NO.
02

SCALE:
NTS

DEALT:
M.J.

DATE:
01.06.2025

CLIENTS:
INDIAN BANK
STATION ROAD,
JANJGIR (C.G.)

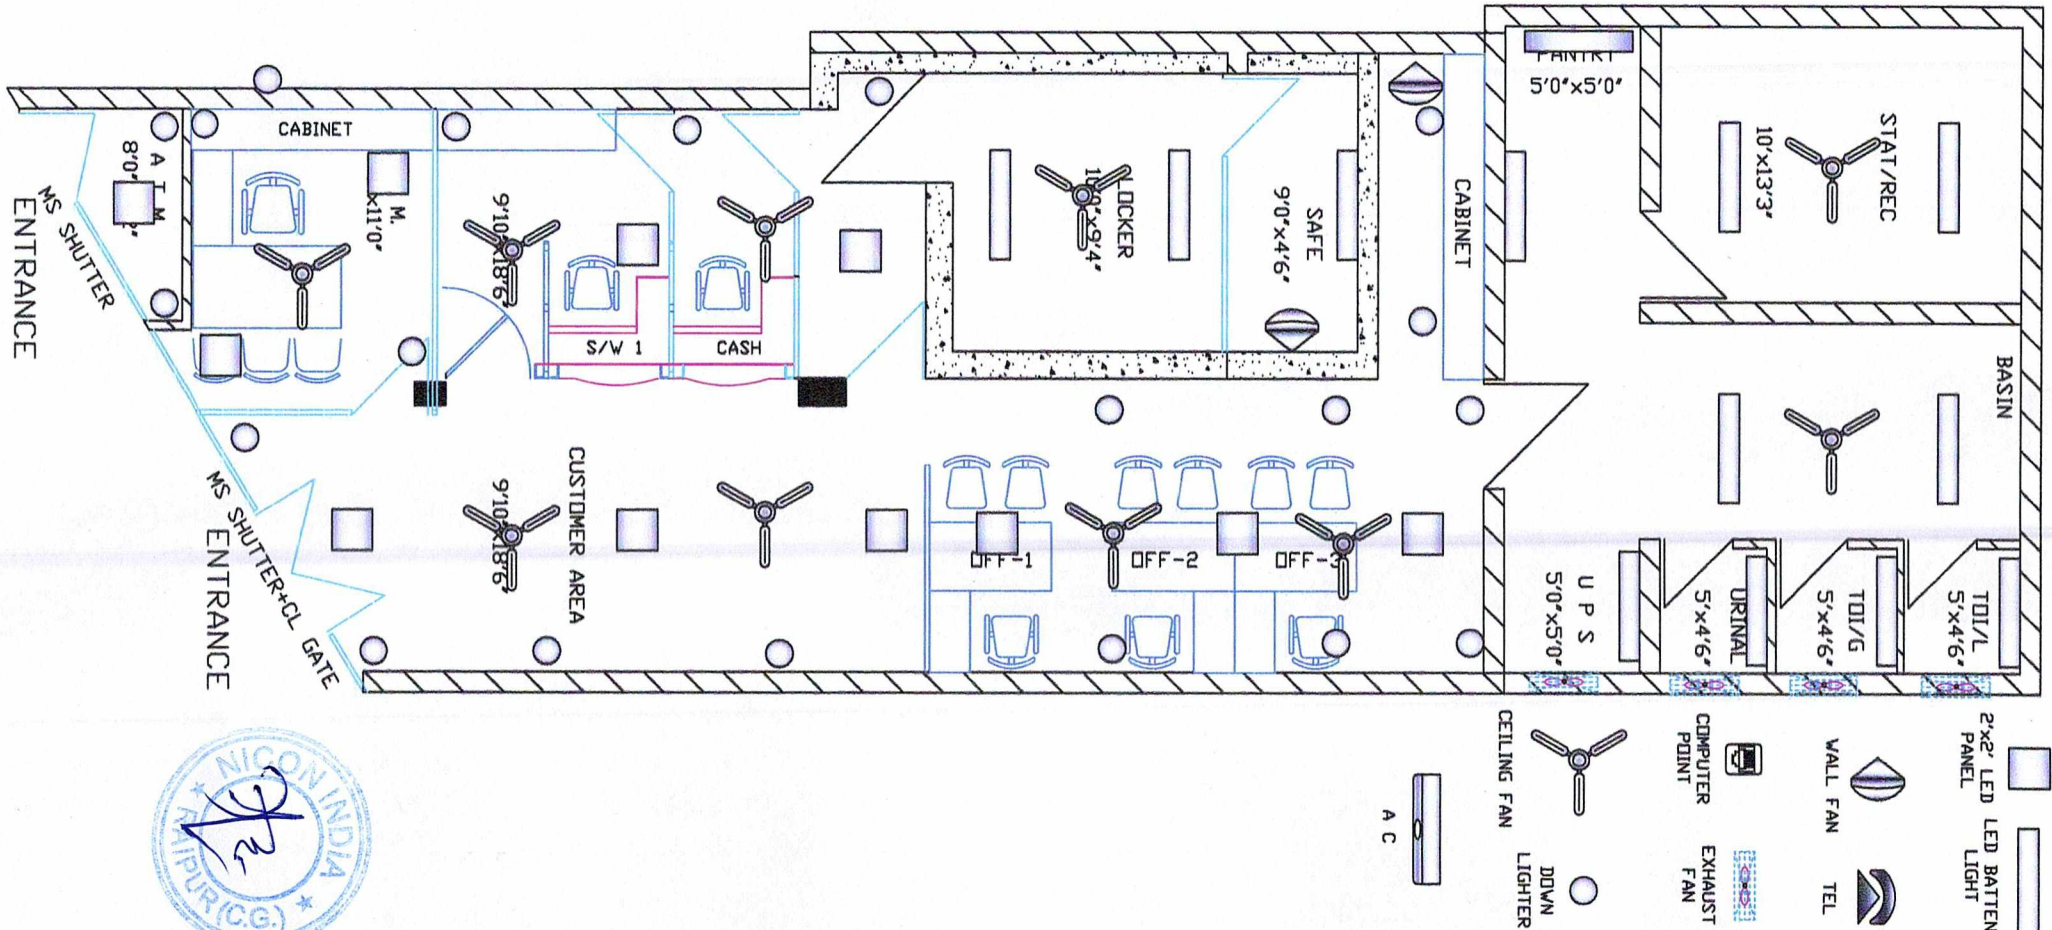

NICON INDIA
34, GURUKUL COMPLEX,
KALIBADI ROAD, RAIPUR. (C.G.)
MOB: 9826323237, 9827158700

TITLE :
ELECTRICAL LAYOUT

DRG. NO.
02

SCALE:
NTS

DEALT:
M.J.

DATE:
01.06.2025

CLIENTS:
INDIAN BANK
STATION ROAD,
JANJGIR (C.G.)