


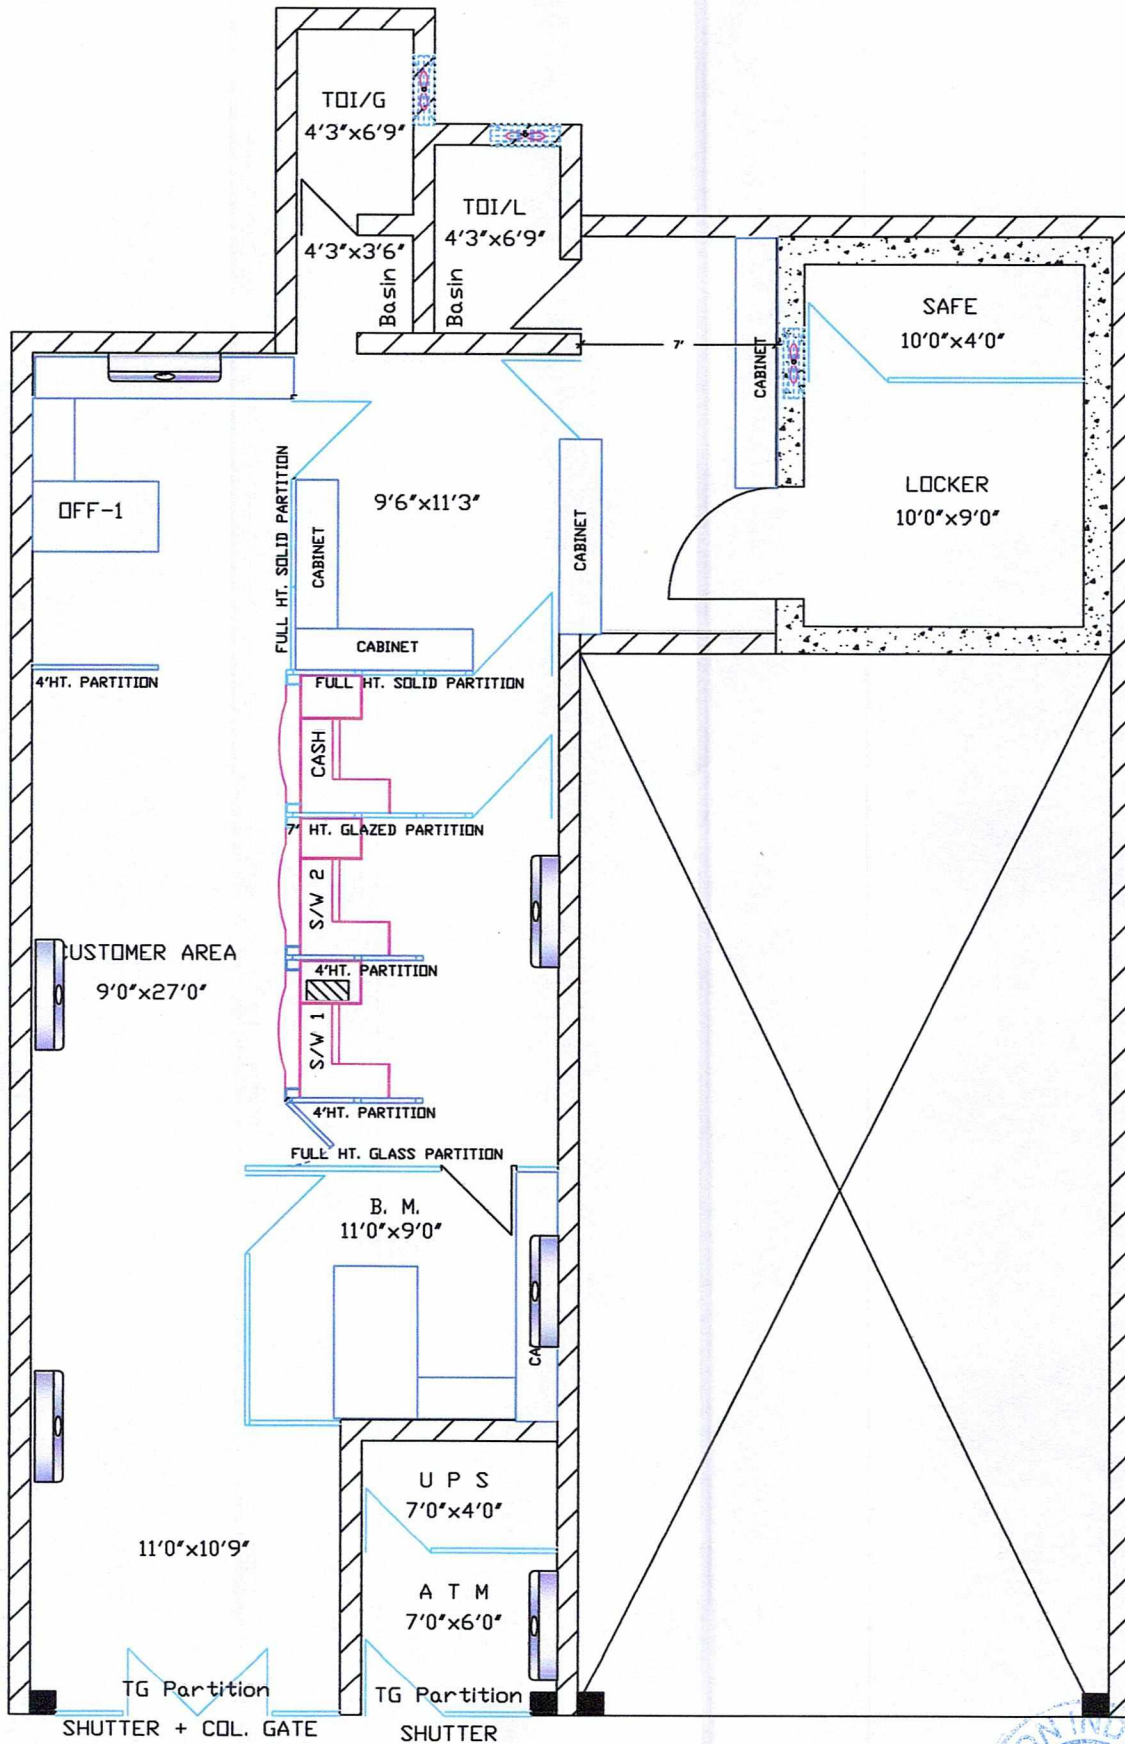

A C



CHUI KAH DAN ROAD

CLIENTS:

INDIAN BANK

CHUI KHADAAN ROAD,

OPP. REST HOUSE, KAIRAGARH

DEAL T:
M.J.

DATE:
20.06.2025

DRG. NO.
03

SCALE:
NTS

TITLE :
AC LAYOUT

NICON INDIA

34, GURUKUL COMPLEX,

KALIBADI ROAD, RAIPUR. (C.G.)

MOB: 9826323237, 9827158700



2'x2' LED
PANEL

LED BATTEN
LIGHT

A C

WALL FAN

TEL


COMPUTER
POINT

EXHAUST
FAN

DOWN
LIGHTER



CEILING FAN

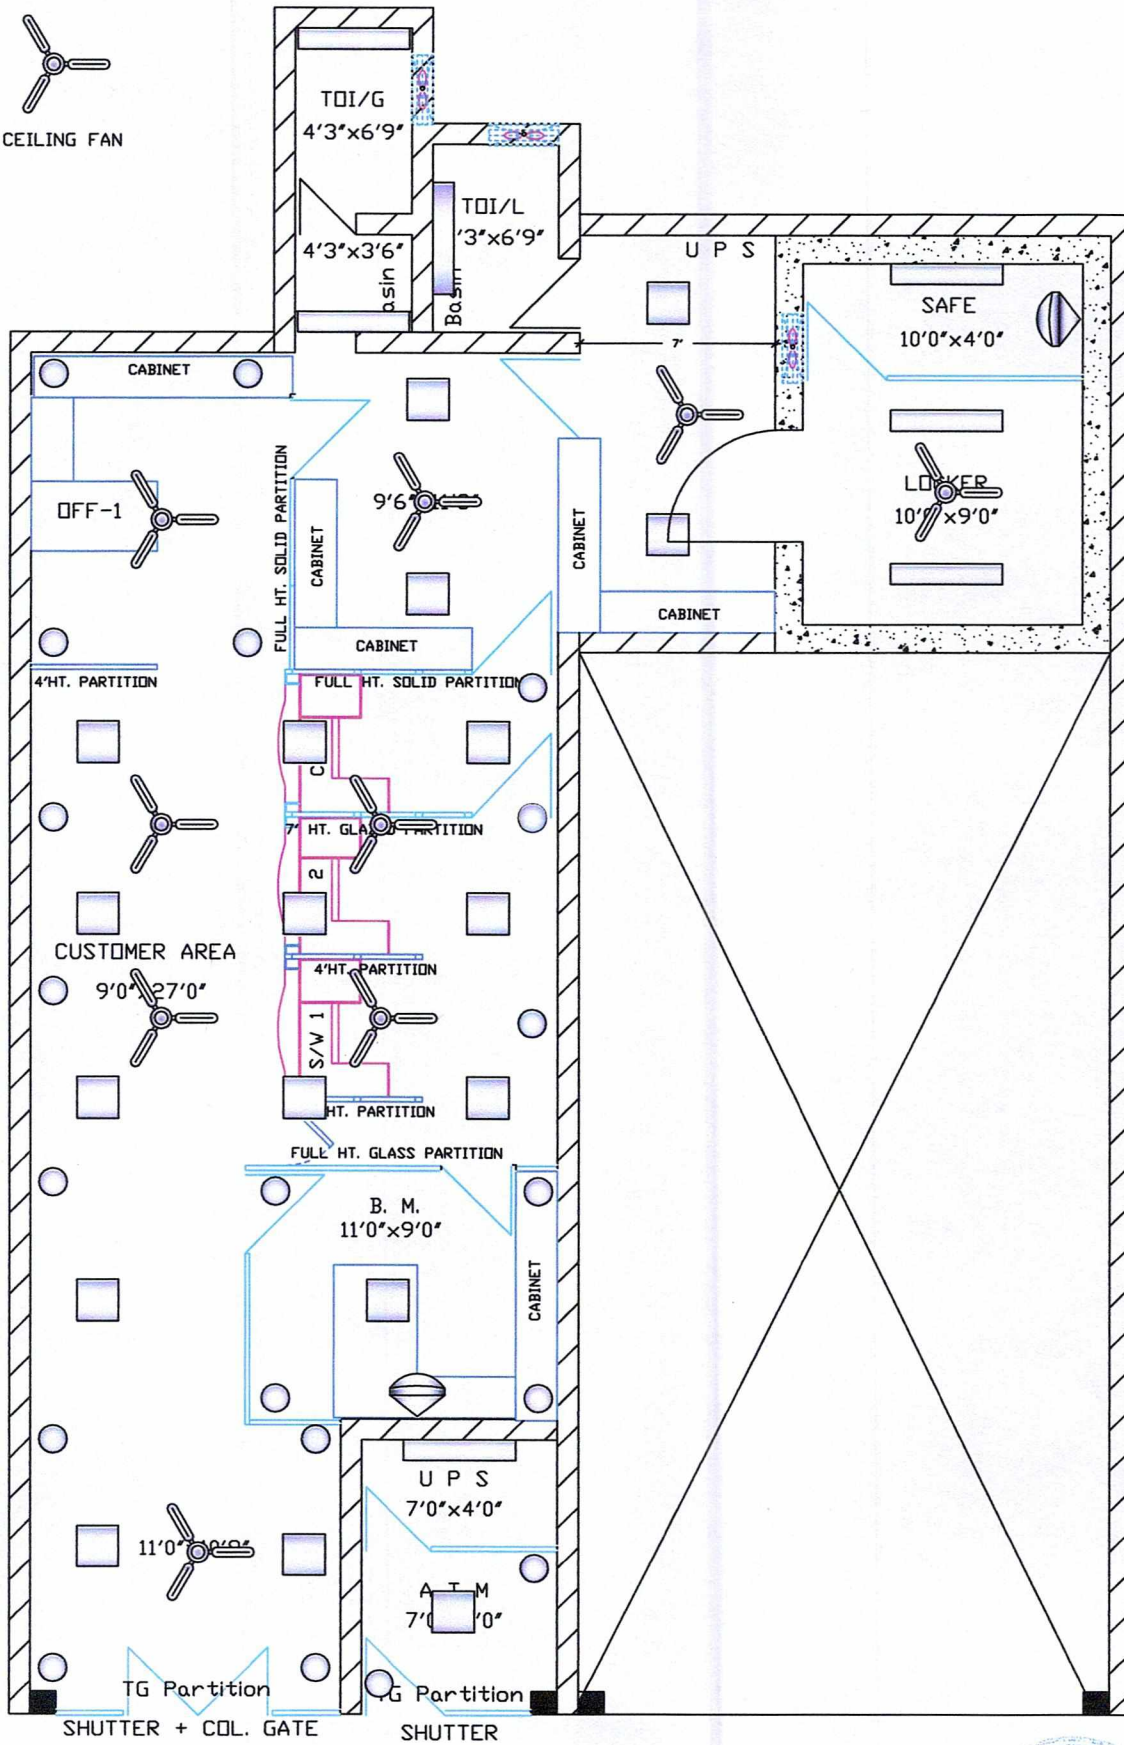

TG Partition
SHUTTER + COL. GATE
ENTRANCE

TG Partition
SHUTTER

CHUI KAH DAN ROAD

CLIENTS:

INDIAN BANK
CHUI KHADAAN ROAD,
OPP. REST HOUSE, KAIRAGARH

DEALT:
M.J.

DATE:
20.06.2025

DRG. NO.
02

SCALE:
NTS

TITLE :
ELECTRICAL LAYOUT

NICON INDIA
34, GURUKUL COMPLEX,
KALIBADI ROAD, RAIPUR. (C.G.)
MOB: 9826323237, 9827158700

