



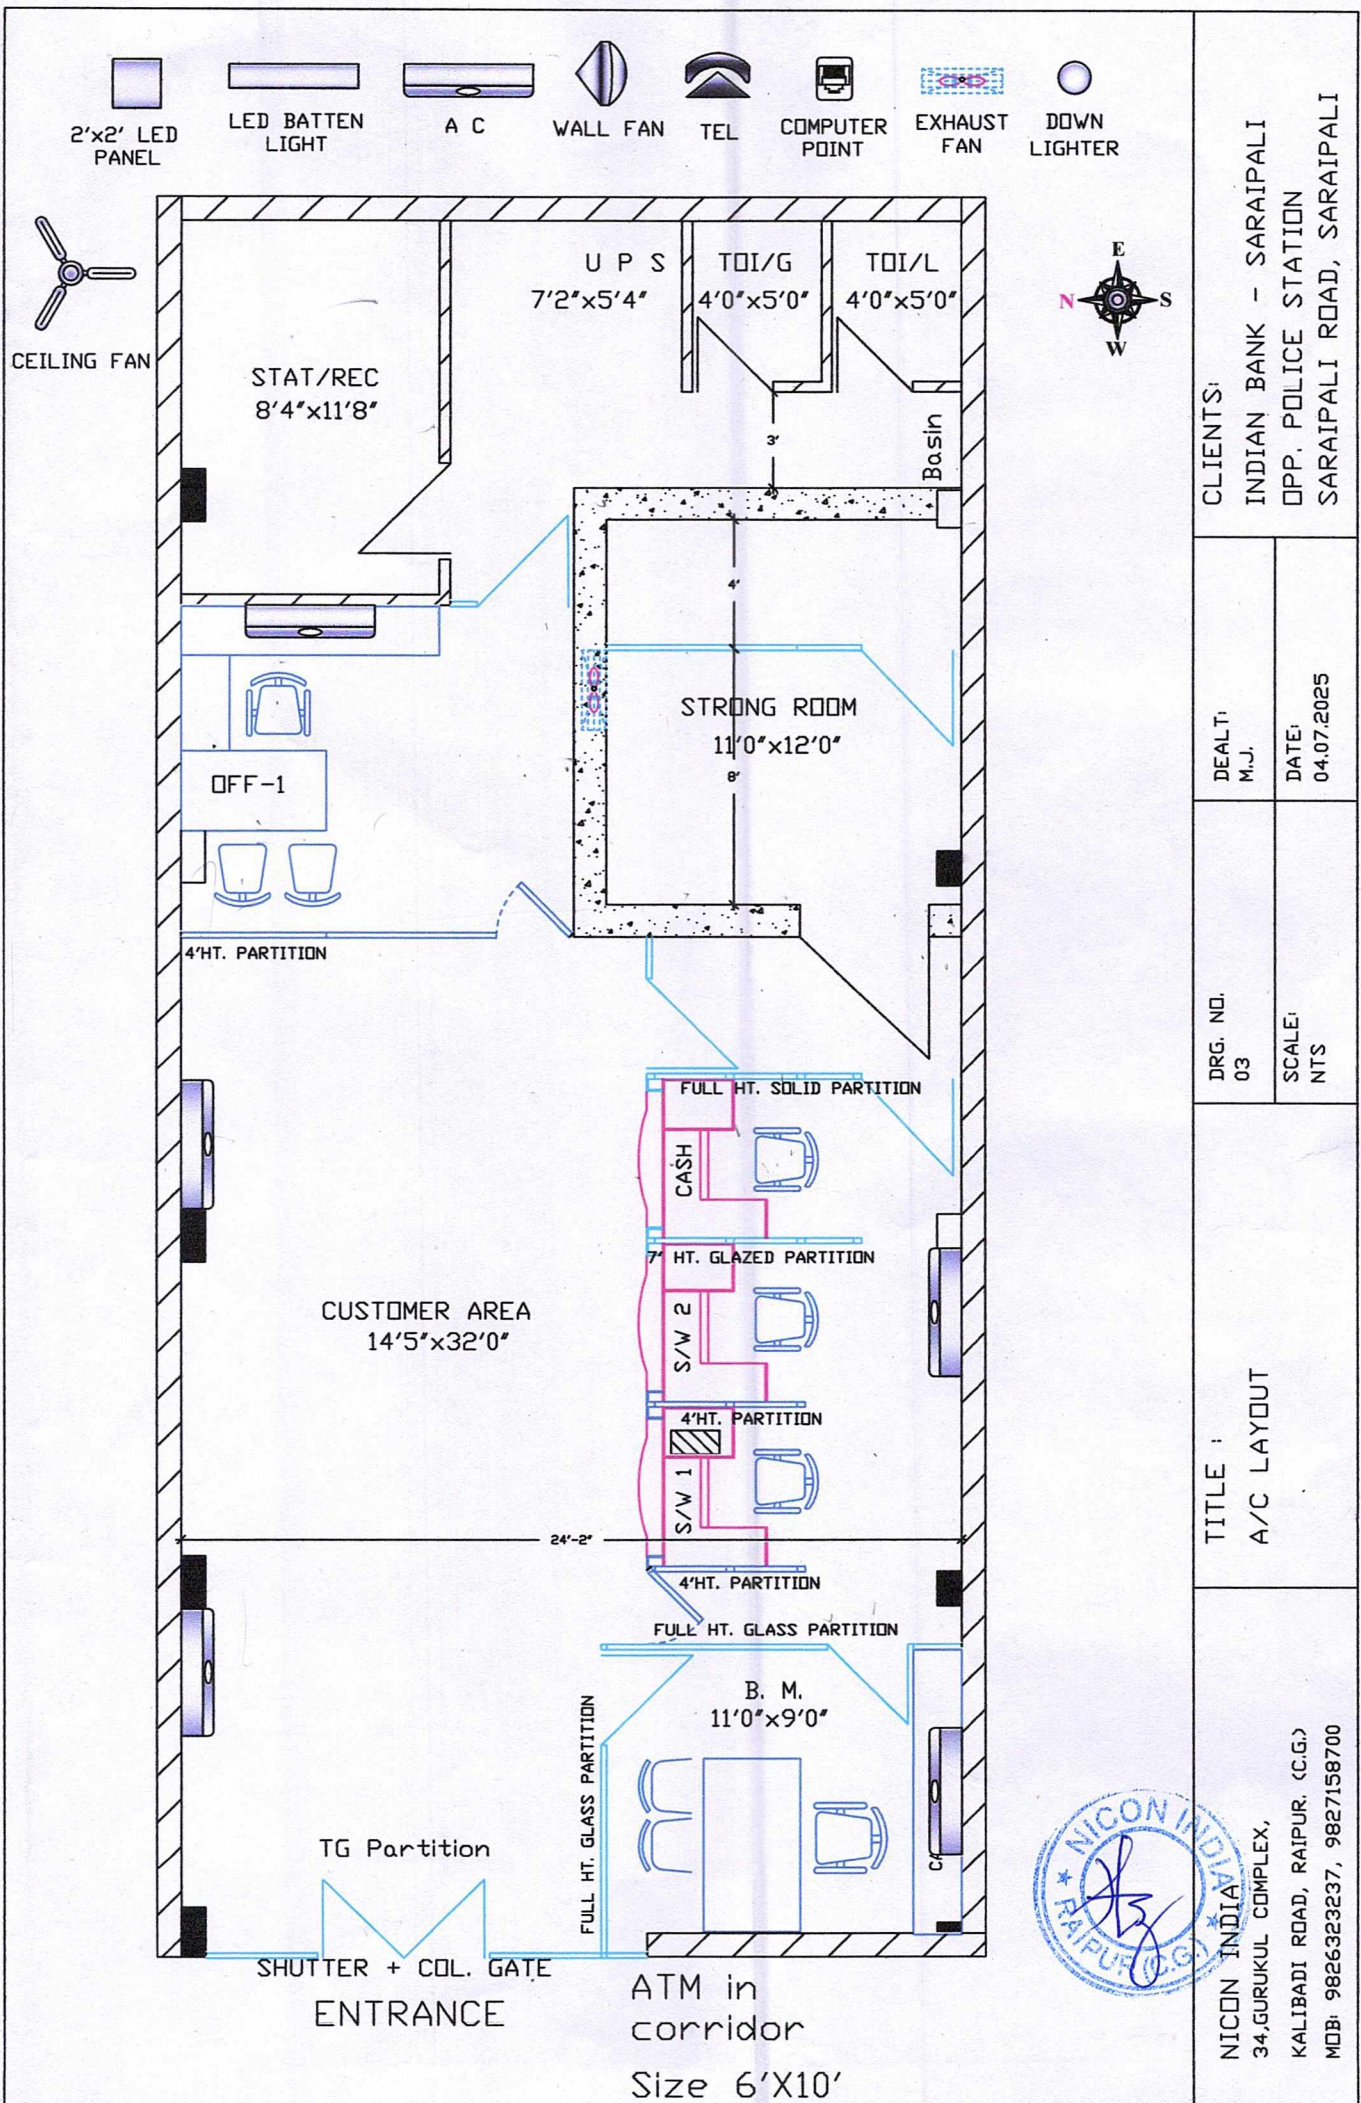

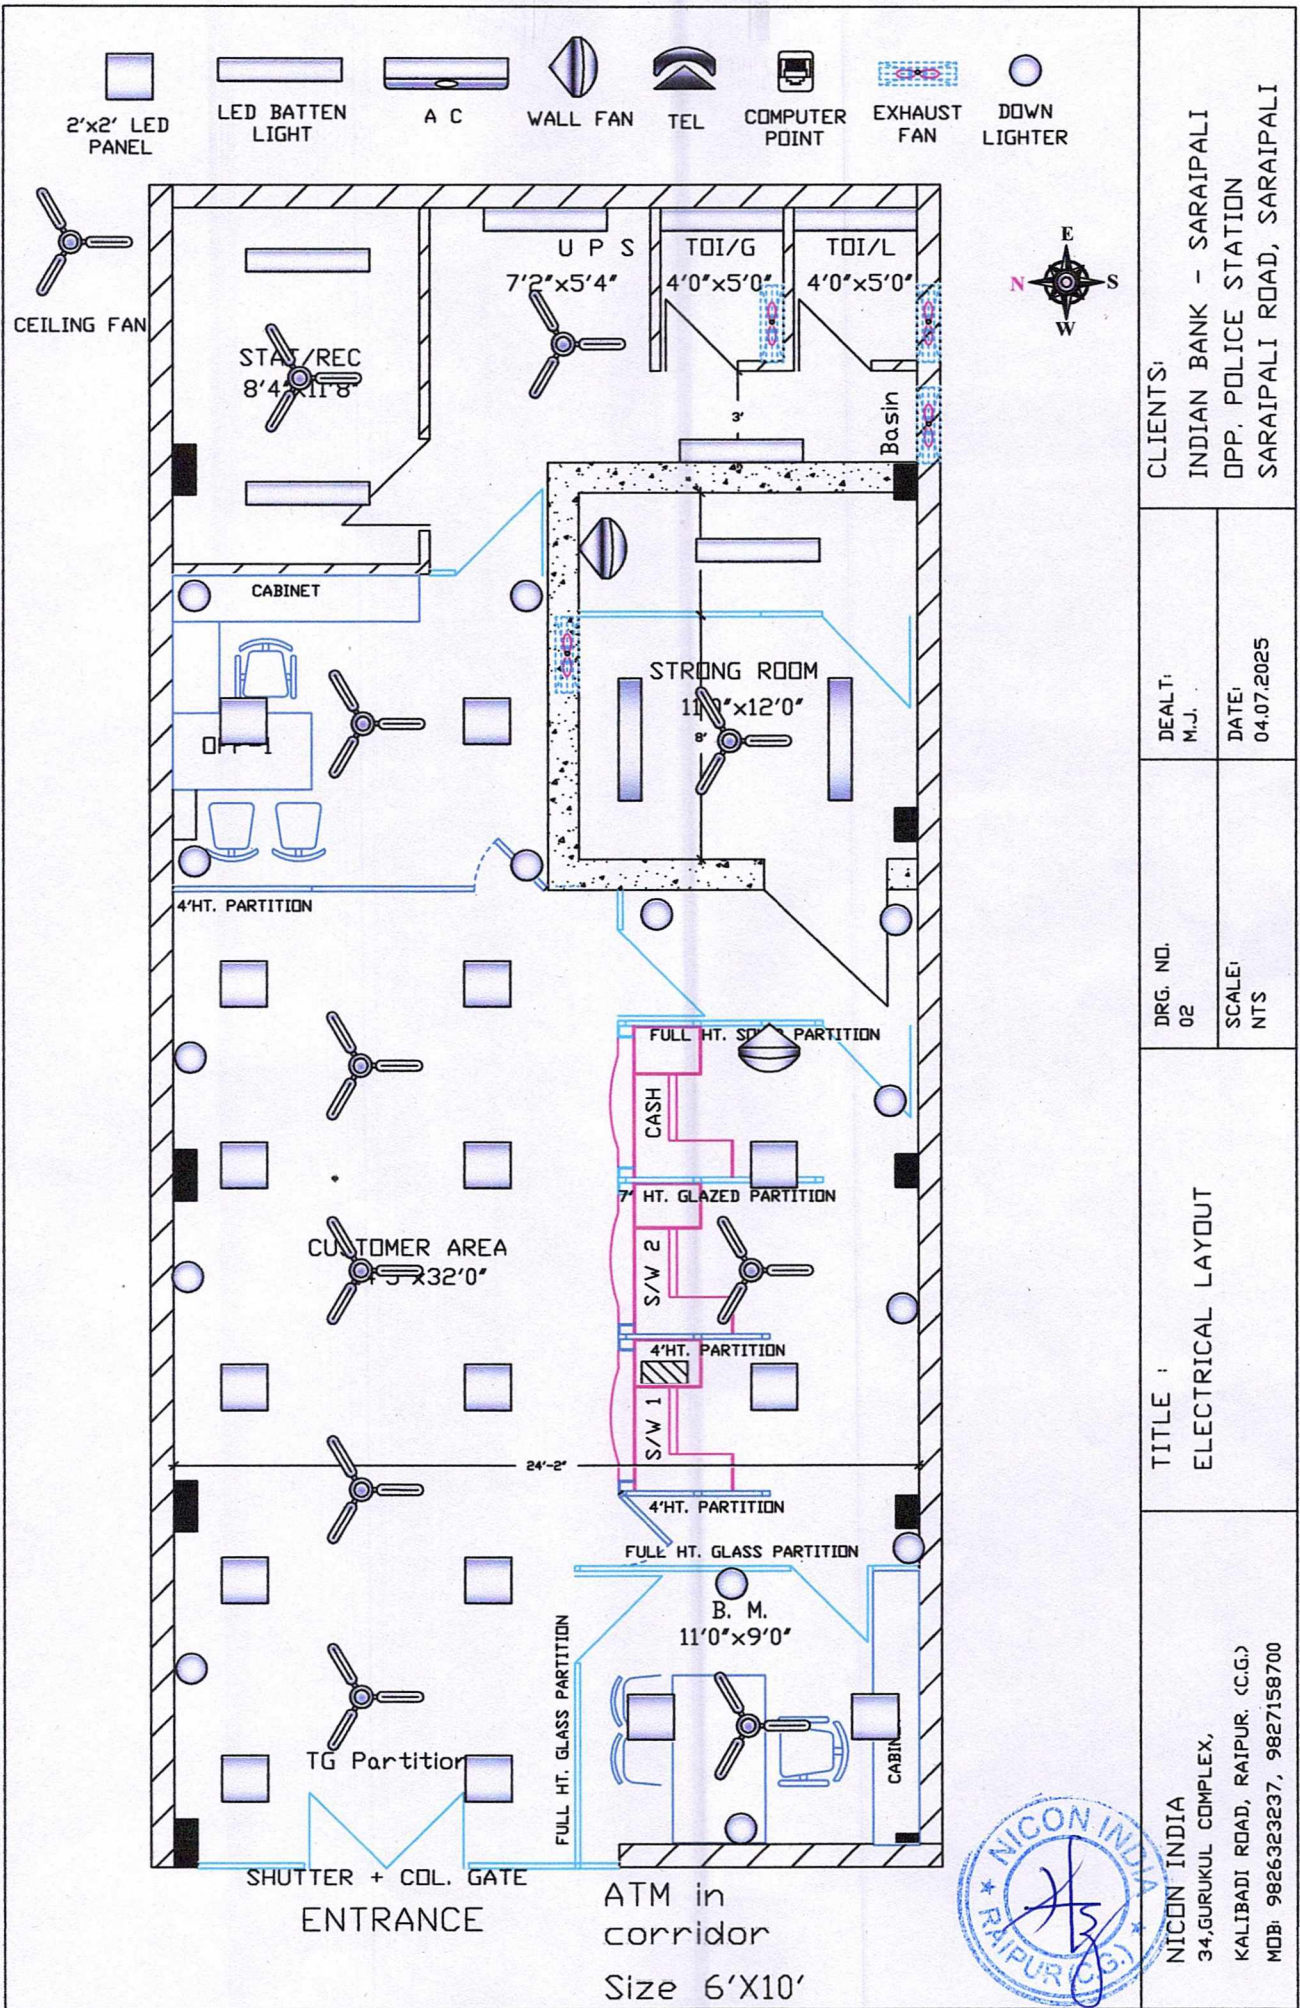

CLIENTS:

INDIAN BANK - SARAIPALI
 OPP. POLICE STATION
 SARAIPALI ROAD, SARAIPALI

DEALT:
 M.J.

DATE:
 04.07.2025

DRG. NO.
 02

SCALE:
 NTS

TITLE :
 ELECTRICAL LAYOUT

NICON INDIA
 34, GURUKUL COMPLEX,
 KALIBADI ROAD, RAIPUR. (C.G.)
 MOB: 9826323237, 9827158700