 





A C

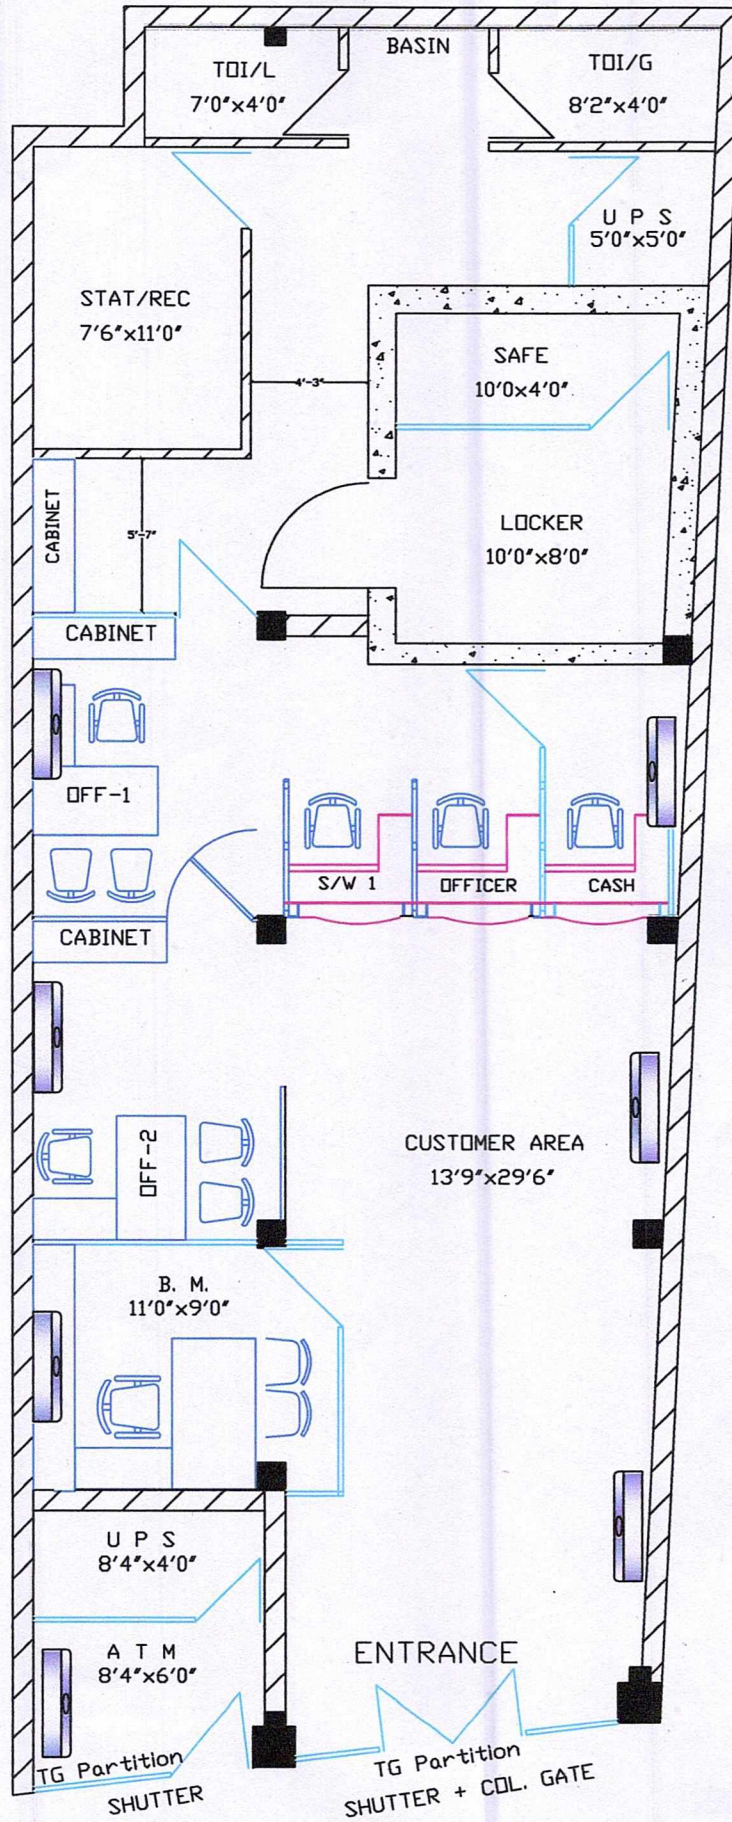

CLIENTS:
INDIAN BANK - SURAJPUR
BHAYATHAN ROAD,
SURAJPUR (C.G.)


DEALT:
M.J.

DATE:
26.06.2025


DRG. NO.
03

SCALE:
NTS

TITLE :
AC LAYOUT

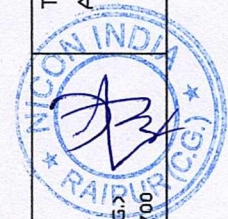

NICON INDIA
34, GURUKUL COMPLEX,
KALIBADI ROAD, RAIPUR. (C.G.)
MOB: 9826323237, 9827158700

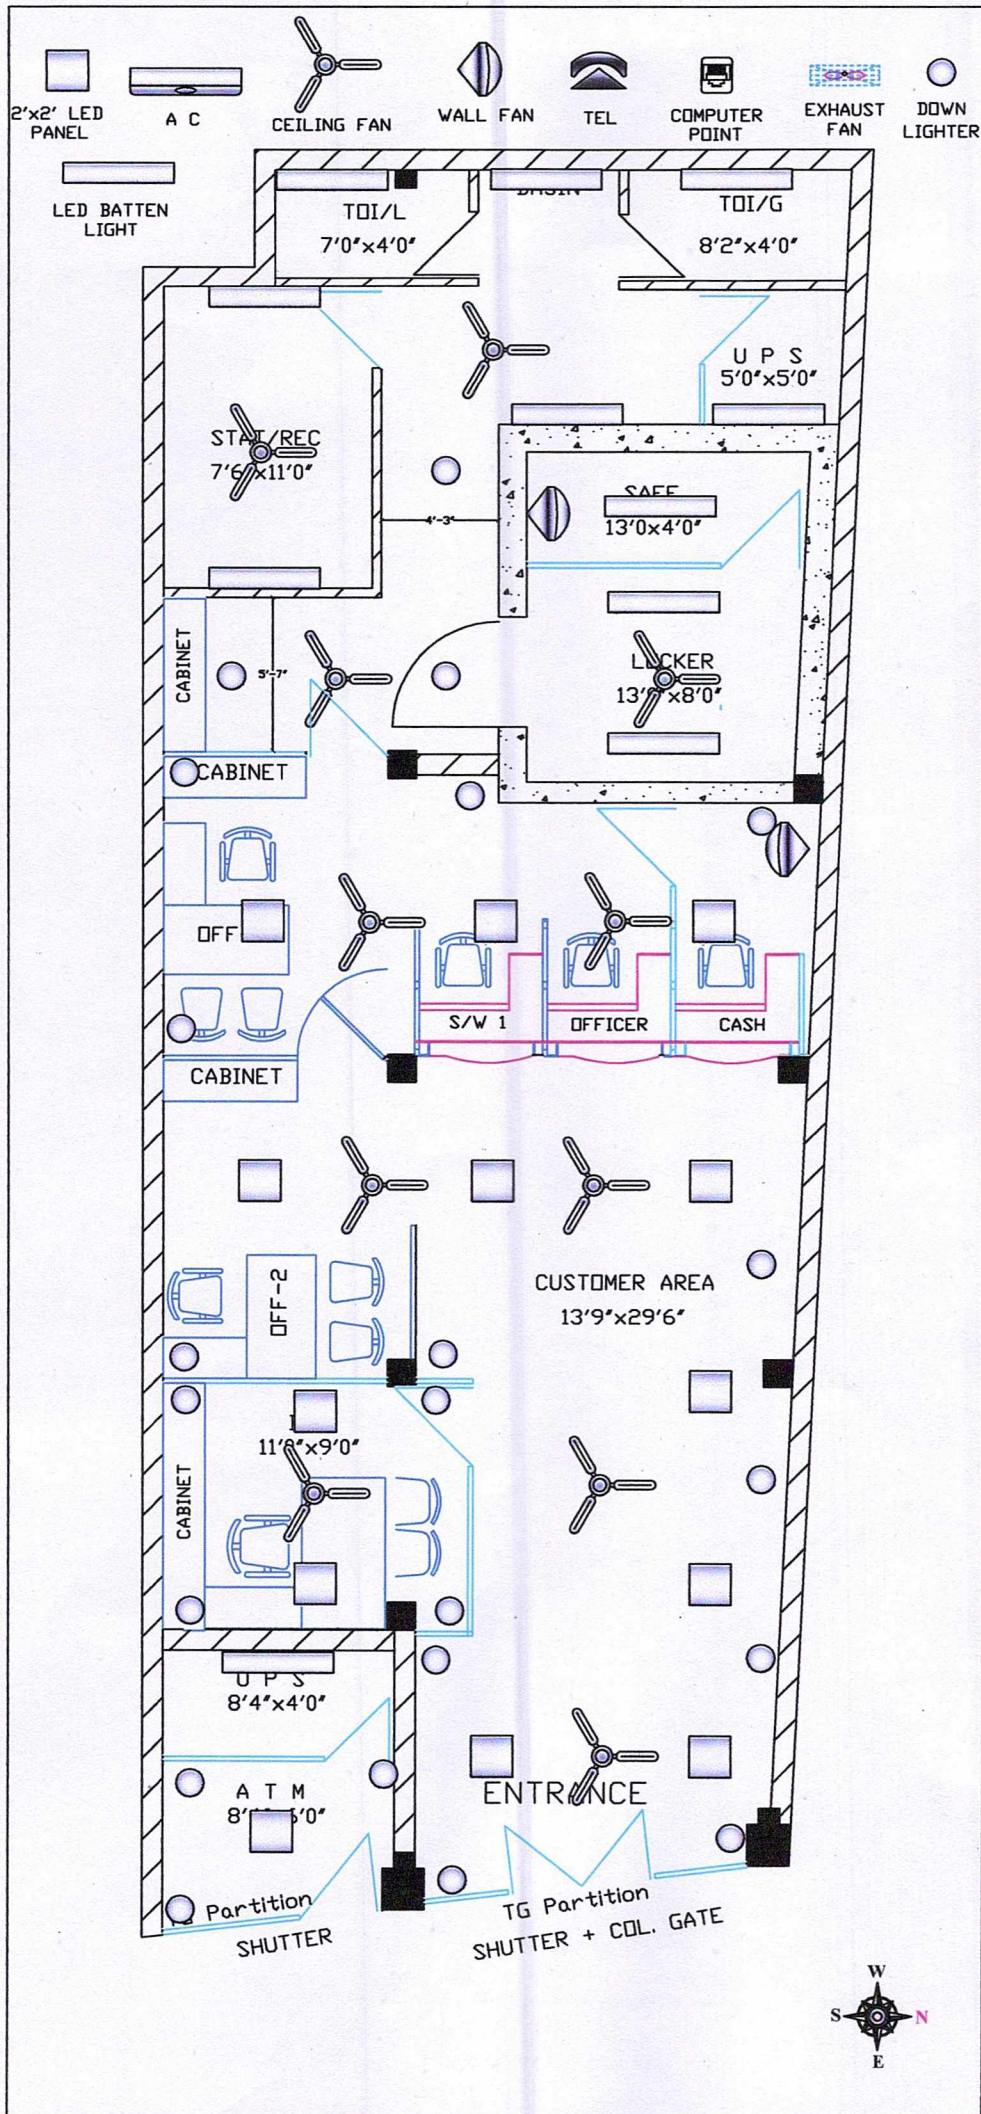

CLIENTS:		INDIAN BANK - SURAJPUR BHAYYATHAN ROAD, SURAJPUR (C.G.)	
TITLE:	DRG. NO.	DEALT:	DATE:
	02	M.J.	26.06.2025
ELECTRICAL LAYOUT		SCALE:	NTS
NICON INDIA 34, GURUKUL COMPLEX, KALIBADI ROAD, RAIPUR. (C.G.) MOB: 9826323237, 9827158700			