


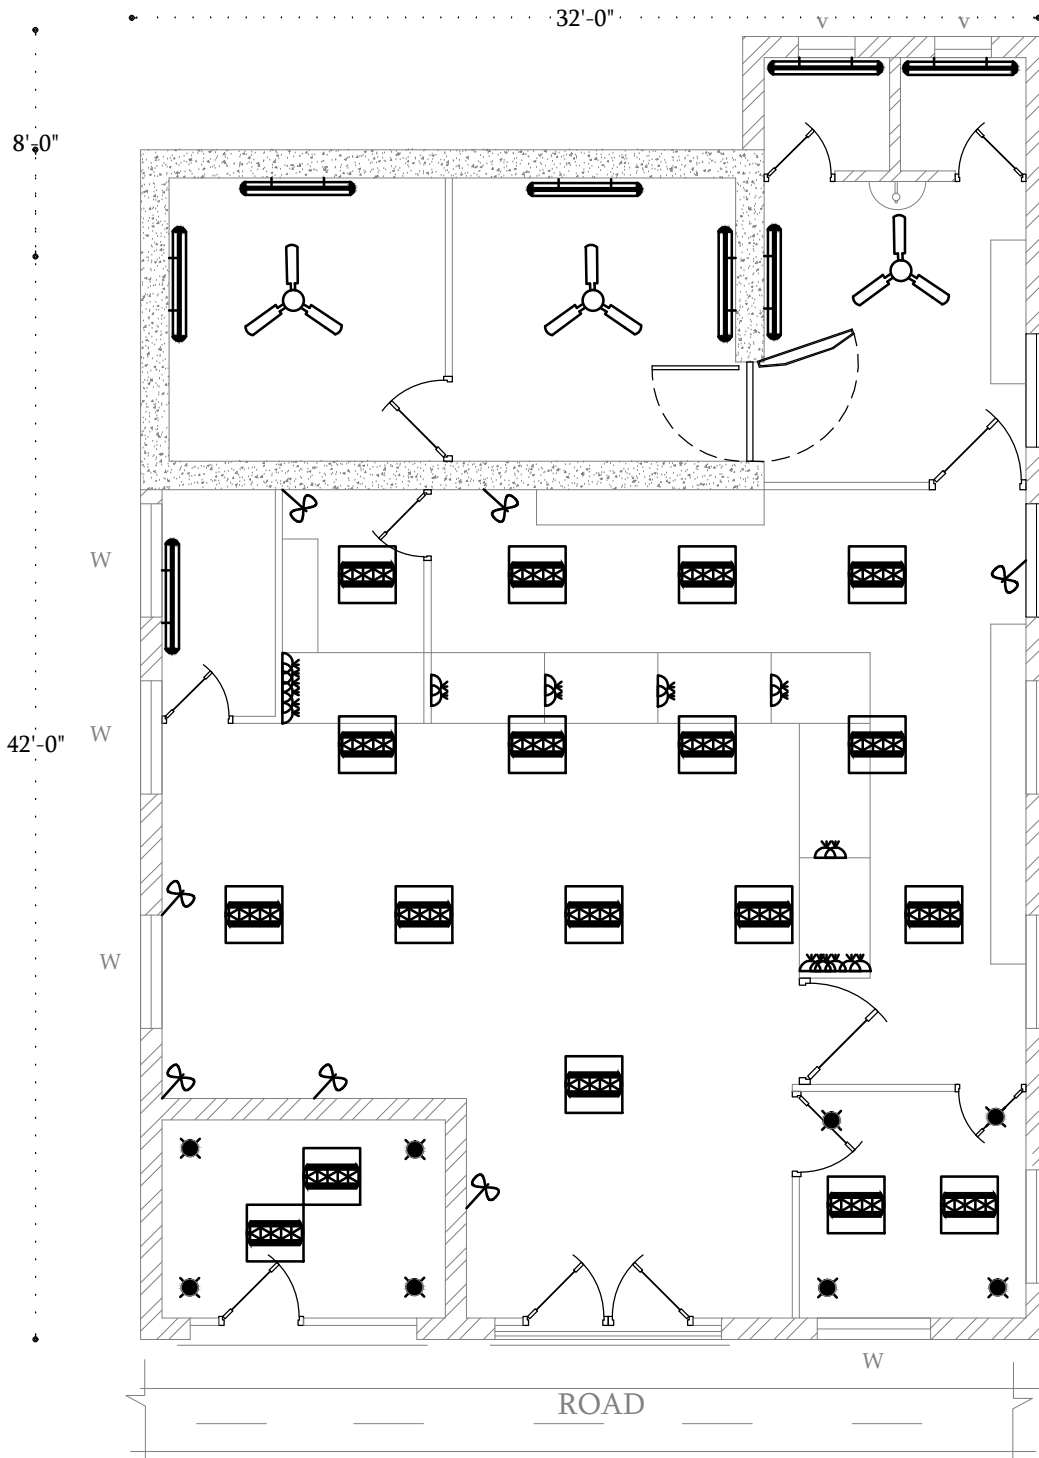

AREA STATEMENT:

AREA DETAIL:	
SAFE ROOM	200.00 SQ.FT
RECORD/DINING/UPS	138.00 SQ.FT
BANKING HALL	809.00 SQ.FT
ATM	80.00 SQ.FT
TOTAL AREA	1227.00 SQ.FT

FALSE CEILING:	
BANKING HALL	809.00 SQ.FT
ATM	80.00 SQ.FT
TOTAL AREA	889.00 SQ.FT

PROJECT

PROPOSED INTERIOR FURNISHING WORK FOR INDIAN BANK AT NANNILAM BRANCH NAGAPPATINAM ZONE

LEGENDS:

	BOX TYPE FITTING 1X36W (WALL)
	BOX TYPE FITTING 1X36W (CEILING)
	CEILING FAN
	WALL MOUNTED FAN 16"DIA (WALL)
	12" EXHAUST FAN
	2/2 MIRROR OPTICAL
	DISTRIBUTION BOARD
	UPS DB
	MAIN PANELL
	CEILING LIGHT
	4 NOS 6A PLUG SOCKET (UPS)

AREA STATEMENT:

OVERALL PLINTH AREA (WITHOUT TOILET) = 1227.00 SQ.FT
TOILET AREA = 35.00 SQ.FT

TITLE

ELECTRICAL LAYOUT



DESIGN	: Er.SANKAR
SCALE	: 1"=1'3"
JOB NO	: I6 - 2024
DATE	: 04.09.2025
SHEET	: A4

ARCHITECT



COS CONSULTANCY SERVICES
ARCHITECTURE, INTERIORS,
STRUCTURAL ENGINEERS &
DESIGNERS

6/13, Kamaraj Nagar 4th Street,
Tallakulam, Madurai - 625002
Phone : 0452 - 2521869
Email id: cosquant93@gmail.com