


INDIAN BANK

THIRUPATHUR BRANCH

(EXISTING PREMISES)

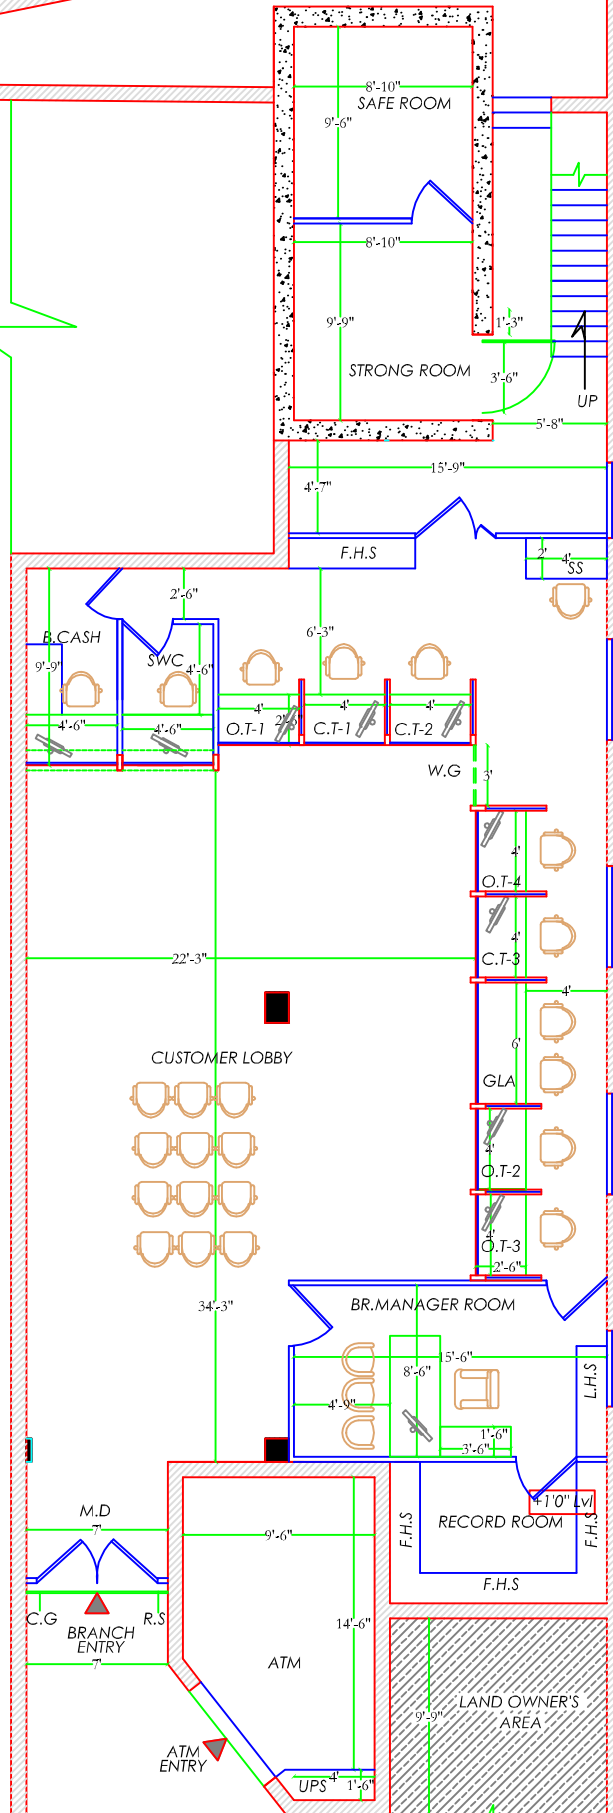

GROUND FLOOR PLAN

NOTE :

ROOF BEAM BOTTOM LVL - 9'3"
ROOF HEIGHT LVL - 10'9"

REFERENCE :

FHGP - FULL HEIGHT GLAZED PARTITION
FHP - FULL HEIGHT PARTITION
F.H.S - FULL HEIGHT STORAGE
O.T - OFFICER'S TABLE
C.T - CLERICAL TABLE
G.L.A - GOLD LOAN APPRAISER
M.D - MAIN DOOR (6'0"X7'0")
D - DOOR (3'0"X7'0")
D1 - DOOR (2'6"X7'0")
W - WINDOW (5'0"X4'6")
W1 - WINDOW (3'9"X4'6")
C.P - COLUMN PANELING
R.S - ROLLING SHUTTER
C.G - COLLAPSIBLE GATE
W.G - WICKET GATE

AREA DETAILS :

Carpet Area of Branch :1943.00 sq.ft
Carpet Area of ATM :133.00 sq.ft

TITLE

TENDER CONCEPT



DRAWN - R.M
JOB NO - 11 -21
DATE - 13.10.2025
SCALE - N.T.S.
SHEET NO - 01

MATHURA ASSOCIATES

ARCHITECTURAL & STRUCTURAL CONSULTANT
INTERIOR DESIGNS - VALUERS - LANDSCAPE

Contact :
99659-81701
96006-31864




Proprietor :
Ar.D.MADHUKANNAN B.Arch.,AIIA.,FIV.,Mem.C.A.
REGISTERED ARCHITECT - COA
EMPANELLED ARCHITECT - INDIAN BANK
GOVT. REGISTERED VALUER - INCOME TAX
Plot No.18/1, 1st Floor, Agasthiyar Street, Opp.Road to Indus Hospital,
Vavuneshapuram Extn., Madurai - 625014,Tamilnadu.

INDIAN BANK

THIRUPATHUR BRANCH

(EXISTING PREMISES)

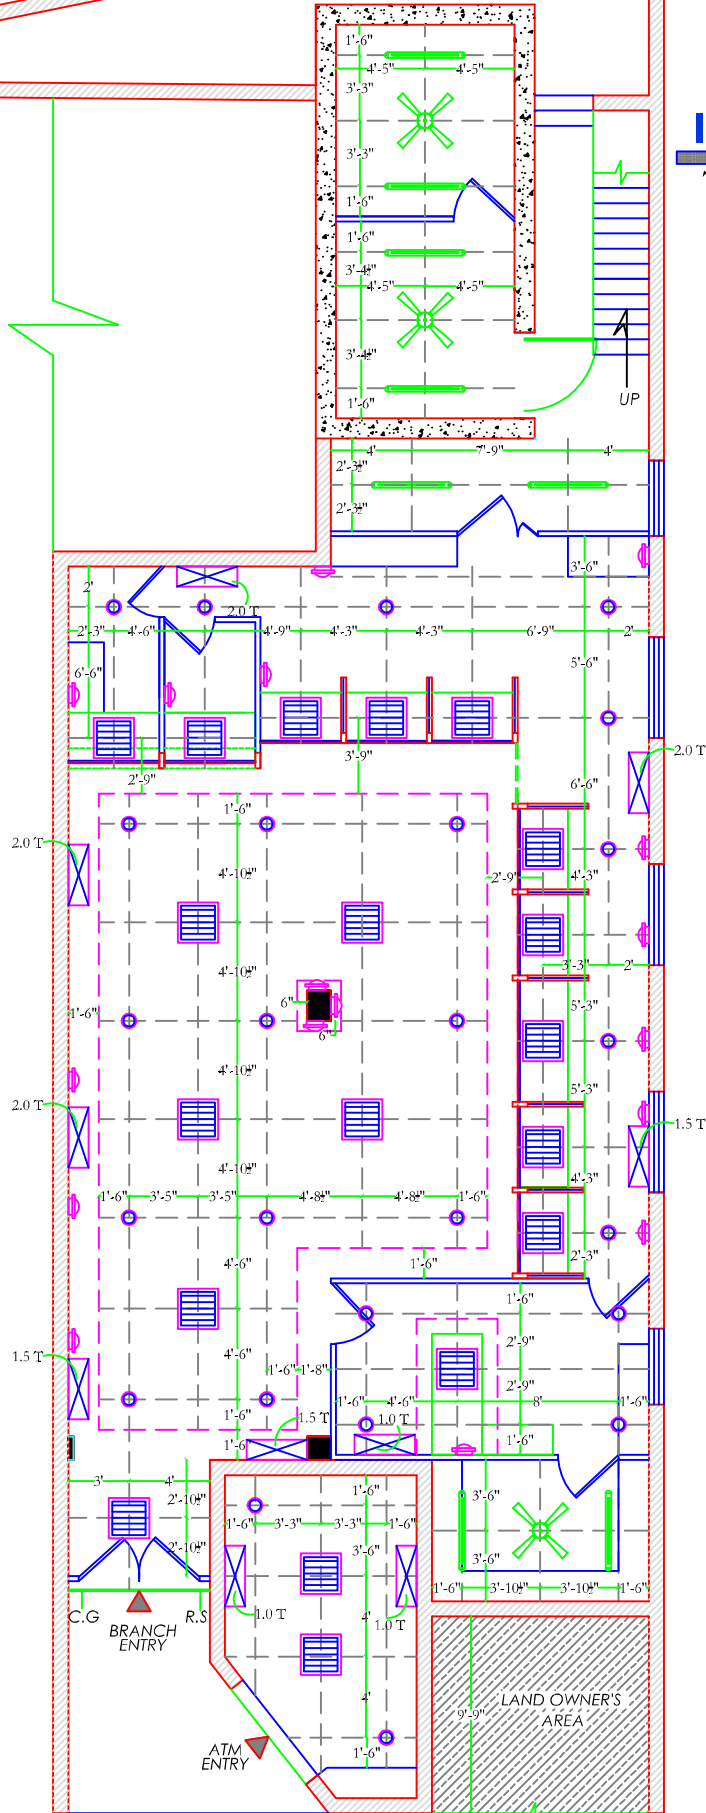

NOTE :

ROOF BEAM BOTTOM LVL - 9'3"
ROOF HEIGHT LVL - 10'9"

REFERENCE :

- A/C - 2.0 Ton - 4 Nos
- A/C - 1.5 Ton - 3 Nos
- A/C - 1.0 Ton - 1 + 2 Nos
- Wall mounted fan - 17 Nos
- Recessed down light LED (2 x 18 W) - 23+2 Nos
- Ceiling fan - 3 Nos
- Tubelight - 8 Nos
- 2'0" x 2'0" LED Recessed 17+2 Nos

AREA DETAILS :

Carpet Area of Branch :1943.00 sq.ft
Carpet Area of A/C :1331.00 sq.ft
Carpet Area of ATM :133.00 sq.ft

TITLE

ELECTRICAL LAYOUT



DRAWN - R.M
JOB NO - 11 -21
DATE - 13.10.2025
SCALE - N.T.S.
SHEET NO - 02

MATHURA ASSOCIATES

ARCHITECTURAL & STRUCTURAL CONSULTANT
INTERIOR DESIGNS - VALUERS - LANDSCAPE

Contact :

99658-81704

96006-31864

Proprietor :

Ar.D.MADHUKANNAN B.Arch., A.I.A., F.I.V., Mem.C.A.,

REGISTERED ARCHITECT - COA

EMPANELLED ARCHITECT - INDIAN BANK

GOVT. REGISTERED VALUER - INCOME TAX

Plot No.16/1, 1st Floor, Agasthiyar Street, Opp.Road to Indus Hospital,

Viswanathapuram Extn., Madurai- 625014,Tamilnadu.



GROUND FLOOR PLAN