


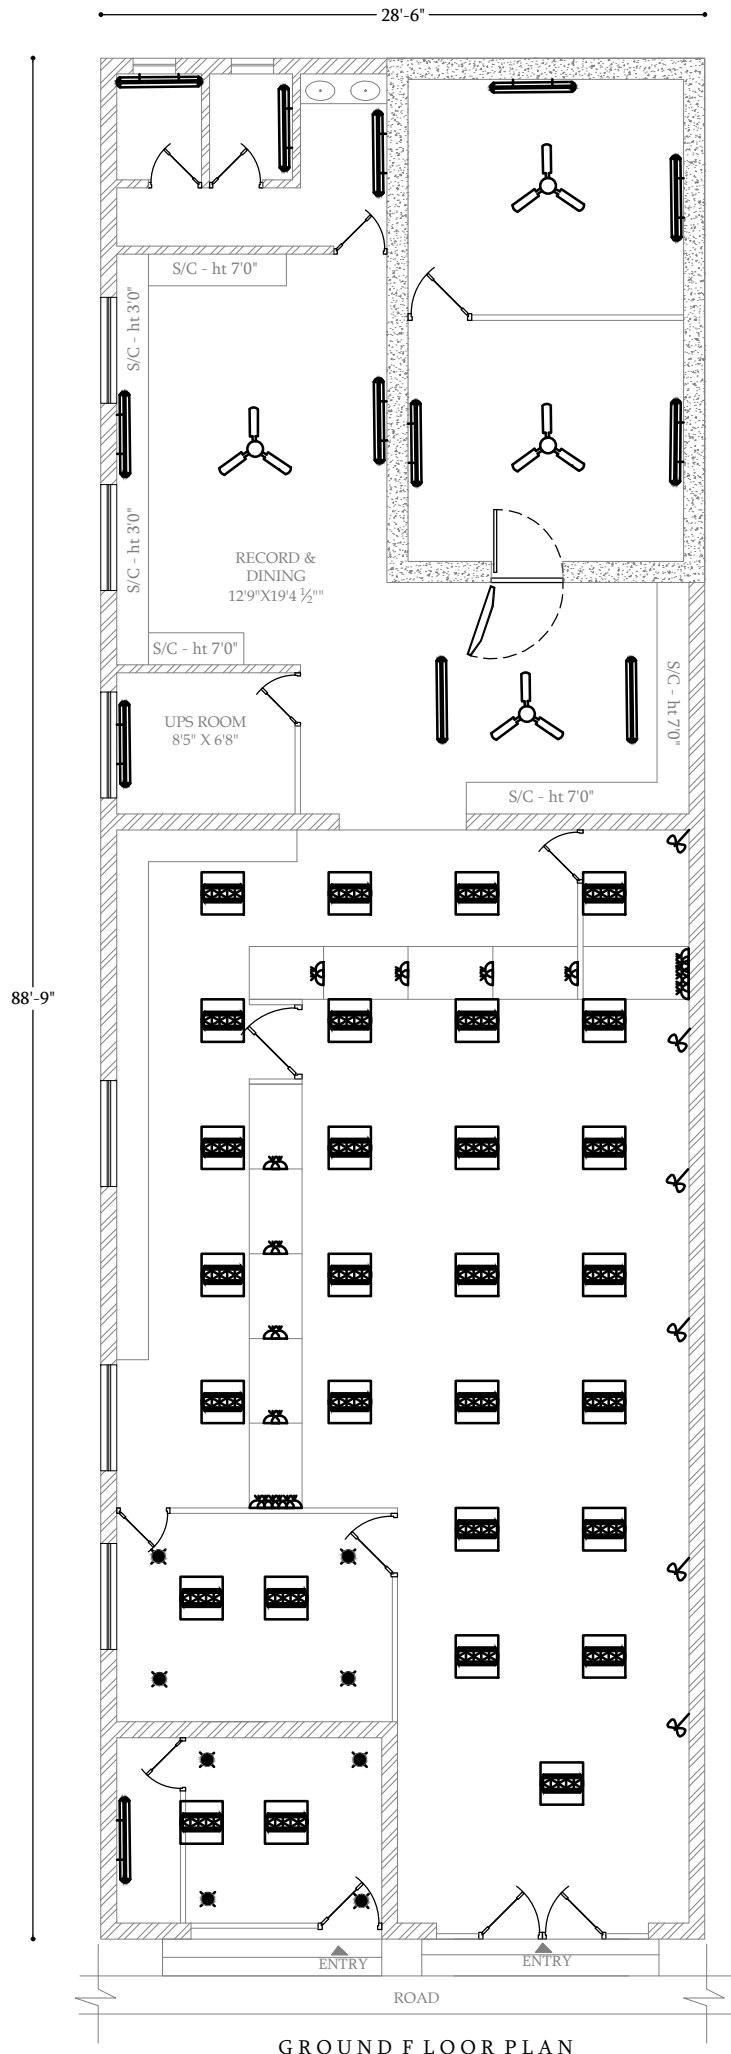

PROJECT

PROPOSED INTERIOR FURNISHING
WORK FOR
INDIAN BANK
AT
CHINNASALEM BRANCH
(CUDDALORE ZONE)

NOTE

- 1) ALL DIMENSIONS ARE IN FEET & INCHES
- 2) DRAWING TO BE READ IN CONJUNCTION WITH DETAILS
- 3) ALL DISCREPANCIES MUST BE BROUGHT TO THE NOTICE OF THE ARCHITECT.

LEGENDS:

	BOX TYPE FITTING 1X36W (WALL)
	BOX TYPE FITTING 1X36W (CEILING)
	CEILING FAN
	WALL MOUNTED FAN 16"DIA (WALL)
	12" EXHAUST FAN
	2/2 MIRROR OPTICAL
	DISTRIBUTION BOARD
	UPS DB
	MAIN PANNEL
	CEILING LIGHT
	4 NOS 6A PLUG SOCKET (UPS)

AREA DETAILING

SAFE ROOM	295.00 SQ.FT
RECORD/DINING ROOM	257.00 SQ.FT
BANKING HALL	1267.00 SQ.FT
ATM	109.00 SQ.FT
TOTAL AREA	1928.00 SQ.FT

FALSE CEILING AREA

BANKING HALL	1267.00 SQ.FT
ATM	109.00 SQ.FT
TOTAL AREA	1376.00 SQ.FT

AREA DETAILS:

1. PLINTH AREA =2530.00 SQ.FT
2. CARPET AREA =1928.00 SQ.FT

TITLE

ELECTRICAL LAYOUT

	DRAWN :Er.SANKAR
	SCALE : 1"=1'3"
	JOB NO: IB-CUD -01-2025
	DATE : 12.11.2025
SHEET SIZE: A4	

ARCHITECT

Ar. T.MAYILVAHANAN, M.E., A.I.I.A., M.C.A., P.hd.,



COS CONSULTANCY SERVICES

ARCHITECTURE, INTERIORS, STRUCTURAL
ENGINEERS & DESIGNERS

6/13, Kamaraj Nagar 4th Street,
Tallakulam, Madurai - 625002

Phone : 0452 - 2521869

Email id: cosquant93@gmail.com